

PERSPECTIVE




REAR VIEW SHOWING PARKING SPACE FOR 60 AND ALUMNI BUILDING



TABLE OF CONTENTS

SHEET NO.	DESCRIPTION	SHEET NO.	DESCRIPTION
A-01	PERSPECTIVE TABLE OF CONTENTS SITE DEVELOPMENT PLAN	A-10	WARDROBE/CLOSET DETAILS
A-02	GROUND FLOOR PLAN SECOND FLOOR PLAN	A-11	WARDROBE/CLOSET DETAILS HANDRAIL DETAILS
A-03	ELEVATION	A-12	TEMPORARY ROOFING /ENCLOSURE DETAILS
A-04	ELEVATION SECTION	A-13	SUN BREAKER DETAILS WOOD SLAT DETAILS
A-05	TILE LAYOUT PLAN STAIR DETAIL	A-14	DOORS AND WINDOWS SCHEDULE
A-06	REFLECTED CEILING PLAN CEILING DETAILS	S-01	CONSTRUCTION NOTES
A-07	TOILET AND BATH DETAIL	S-02	CONSTRUCTION NOTES
A-08	TOILET AND BATH DET. CONT.	S-03	FOUNDATION PLAN TYPICAL COLUMN DETAIL TYPICAL FOOTING DETAIL FOOTING SCHEDULE GRADE BEAM SCHEDULE
A-09	TOILET AND BATH DET. CONT.	S-04	COLUMN SCHEDULE
		S-05	SECOND FLOOR BEAM FRAME SECOND FLOOR BEAM SCHED
		S-06	SECOND FLOOR BEAM SCHED SCHEDULE OF SLABS TYP. BEAM DETAIL SUSPENDED PLANT BOX DET.
		S-07	TYP. ONE-WAY SLAB DET. TYP. TWO-WAY SLAB DET.
		E-01	GFLR LIGHTING LAYOUT GFLR POWER LAYOUT
		E-02	2FLR POWER LAYOUT MDP SCHEDULE OF LOADS NOTES, SYMBOLS & LEGEND
		E-03	SCHEDULE OF LOADS
		E-04	SCHEDULE OF LOADS SINGLE LINE DIAGRAMS
		P-01	GFLR SANITARY LINE LAYOUT 2FLR SANITARY LINE LAYOUT
		P-02	GFLR WATER LINE LAYOUT 2FLR WATER LINE LAYOUT
		P-03	TYP. PLUMBING DETAILS
		P-04	TYP. PLUMBING DETAILS NOTES AND LEGEND SEPTIC TANK DETAIL




FRONT VIEW SHOWING HOSTEL BUILDING FOOTPRINT

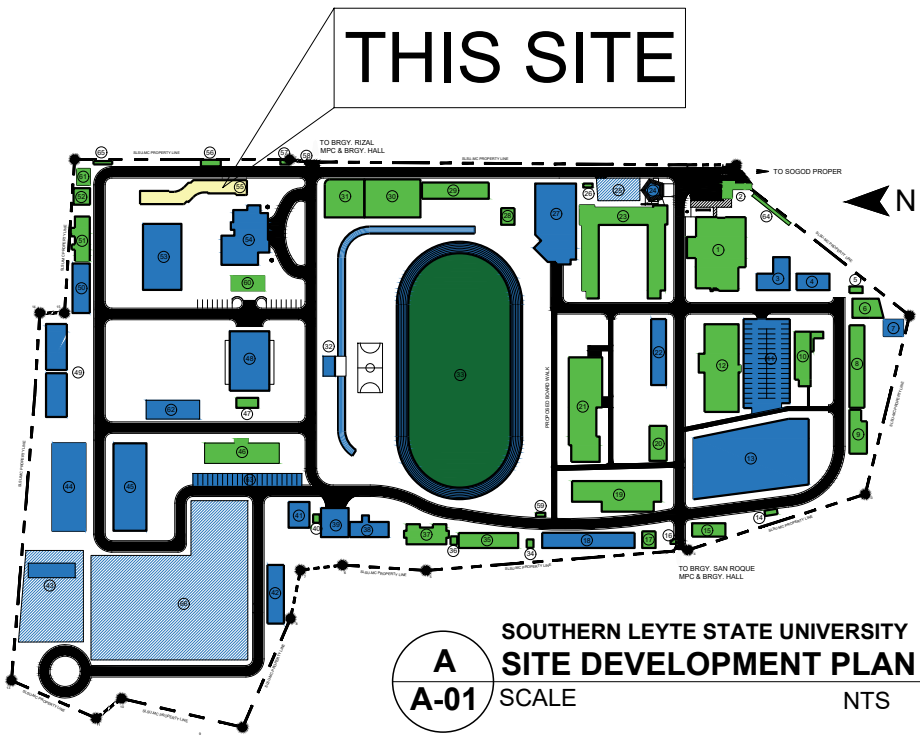


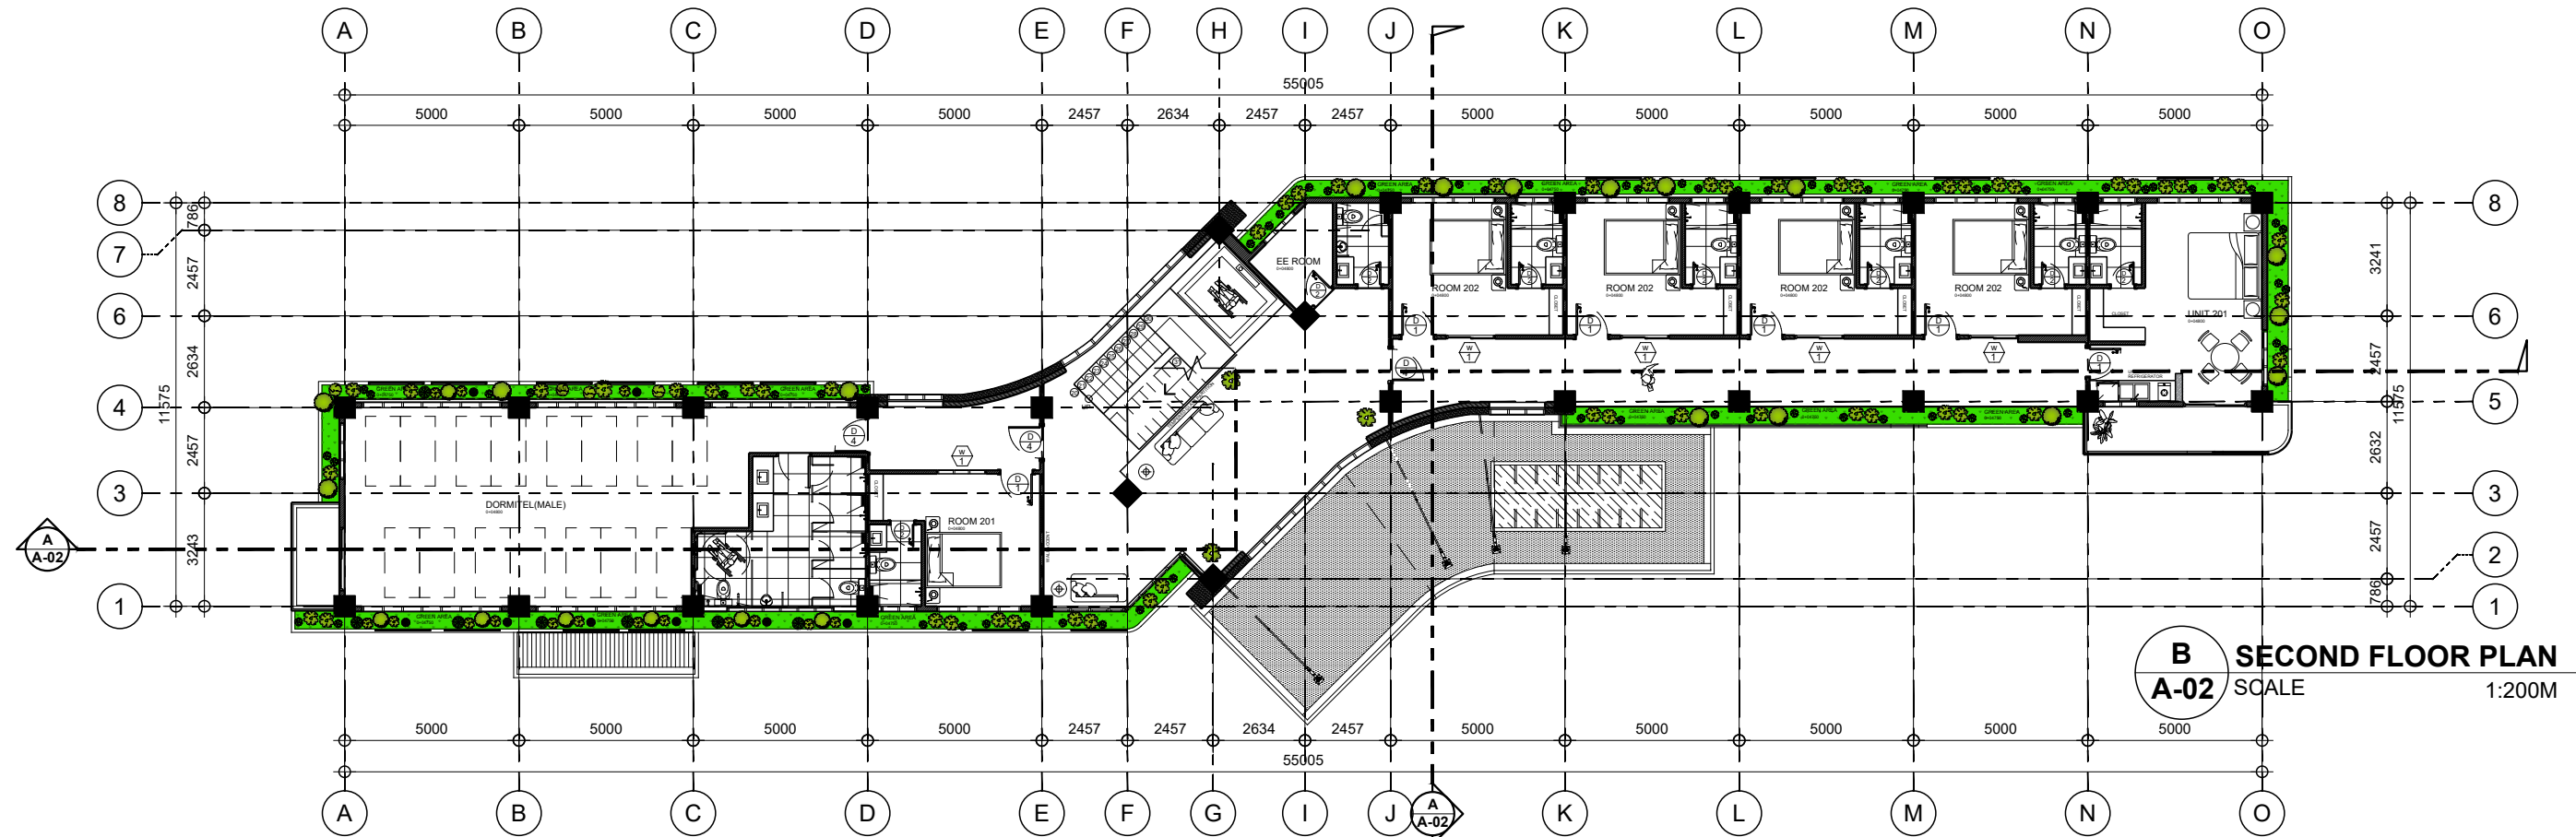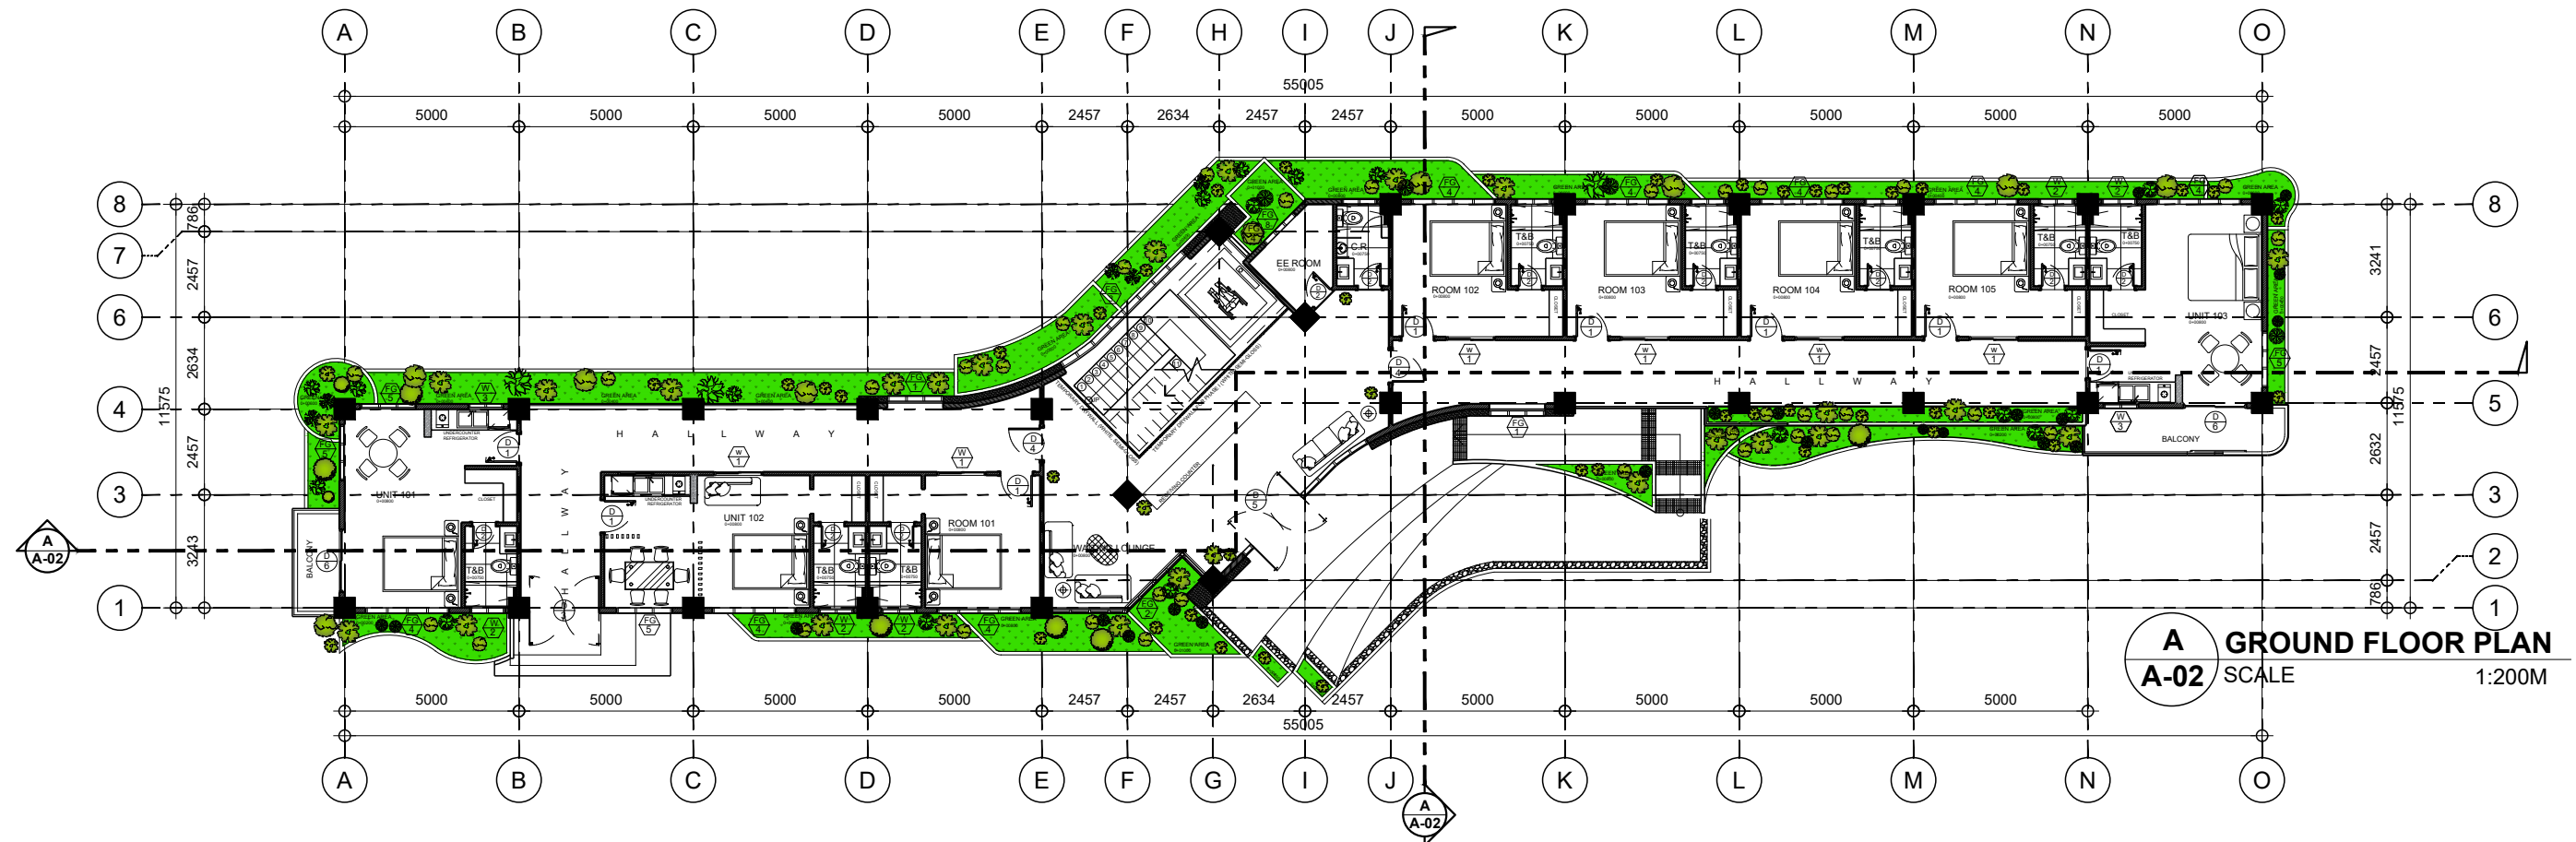

 SOUTHERN LEYTE STATE UNIVERSITY Main Campus, San Roque, Sogod, Southern Leyte Email: president@southernleytestateu.edu.ph Website: www.southernleytestateu.edu.ph	PREPARED BY:		PROJECT:	OWNER:	APPROVED AS PER PLAN:	SHEET CONTENT		SHEET NO.
	BYRON A. ENGASTON	AR. JEAMES PAUL EVANGELISTA, UAP	CONSTRUCTION OF 3-STOREY, 30 ROOMS APARTELE DE SLSU PHASE I	SOUTHERN LEYTE STATE UNIVERSITY	JUDE A. DUARTE, DPA UNIVERSITY PRESIDENT	AS SHOWN		A-02
	MARJORIE G. ELEJORDE	ARCHITECT				CHECKED : APPROVED :	DRAWN : DATE :	PROJ. NO.
Excellence Service Leadership and Good Governance Innovation Social Responsibility Integrity Professionalism Spirituality	MARK CIELLO A. UYPALA DRAFTING AIDE-QJT	ENGR. RYAN A. MACUTO, GREEN ADP+AA LUDIP Head Designate	ADDRESS: SLSU-MAIN CAMPUS, SAN ROQUE, SOGOD SOUTHERN LEYTE	ADDRESS: SLSU-MAIN CAMPUS, SAN ROQUE, SOGOD SOUTHERN LEYTE		SCALE AS SHOWN @ 20x30		

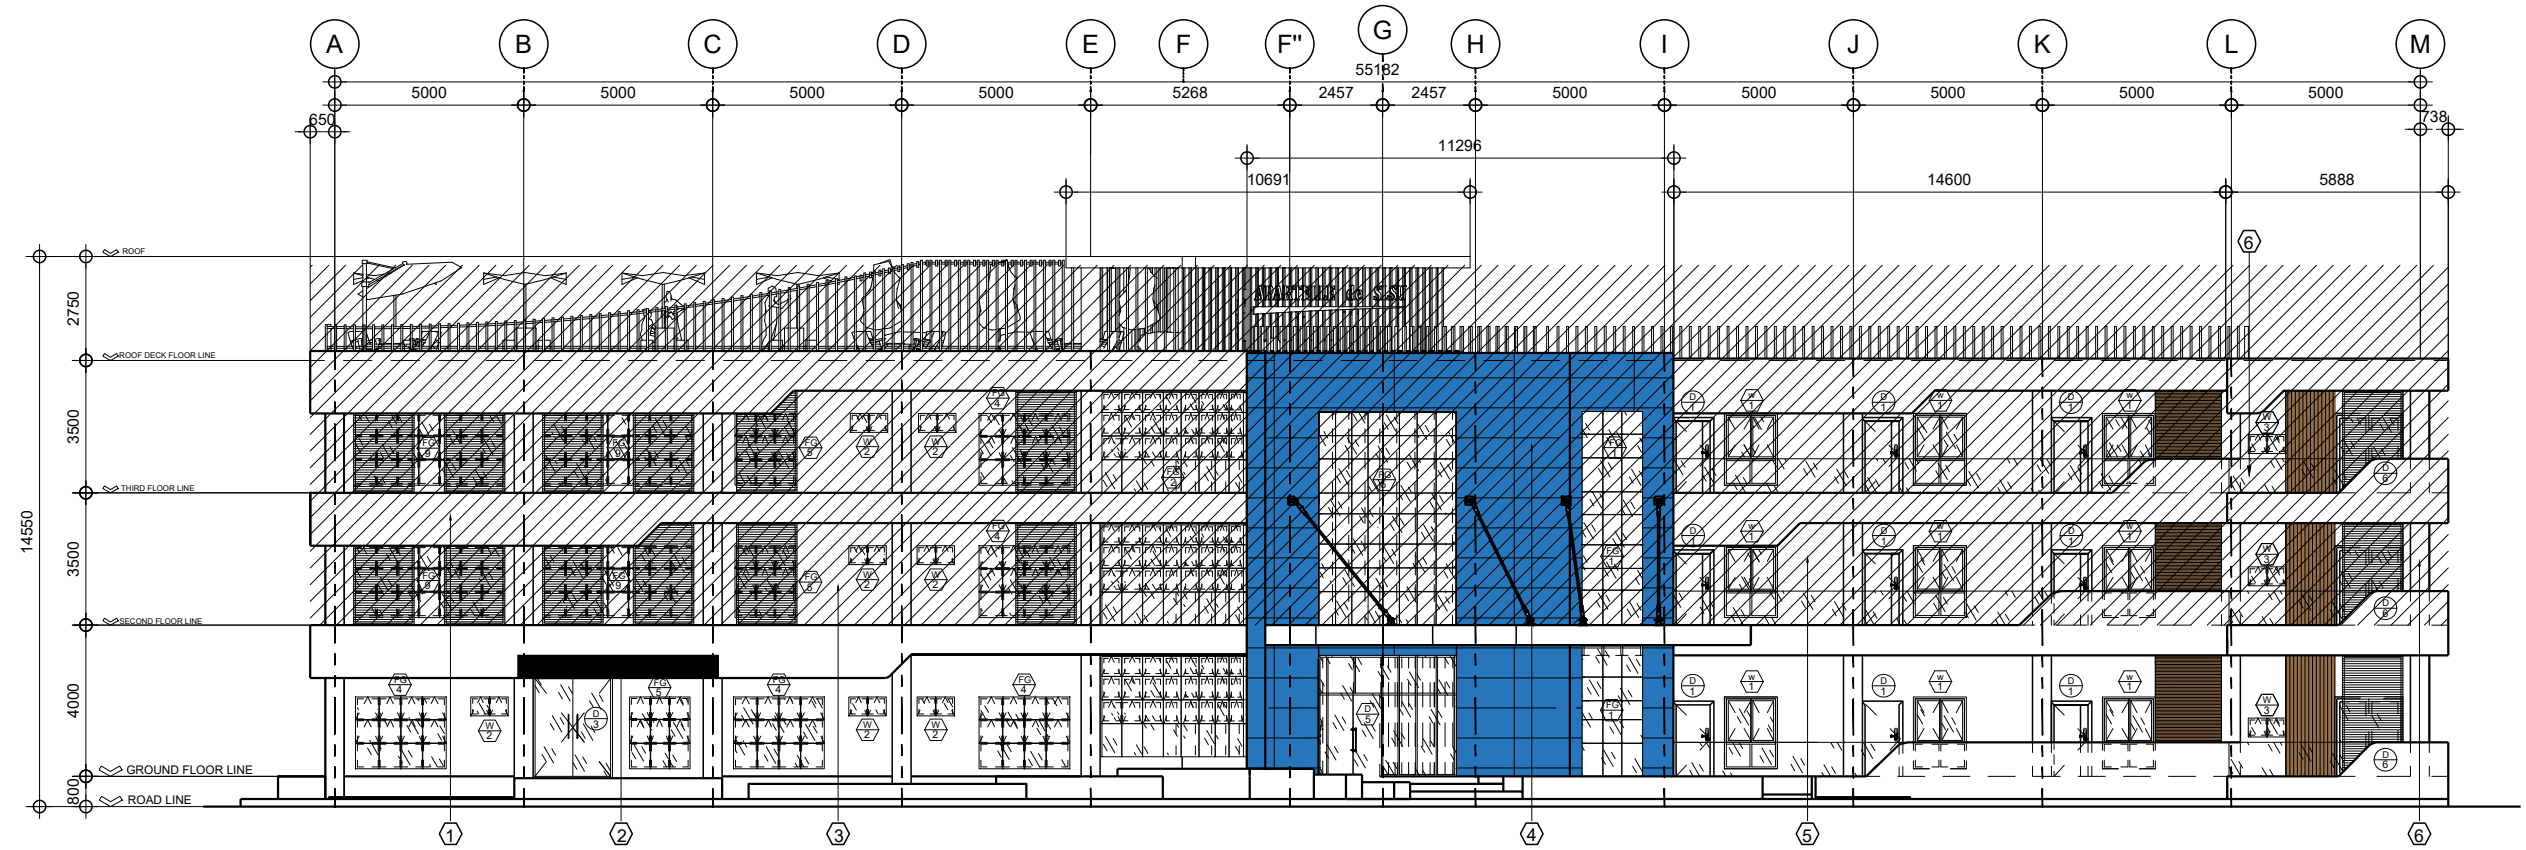

A FRONT ELEVATION
A-03 SCALE 1:200M

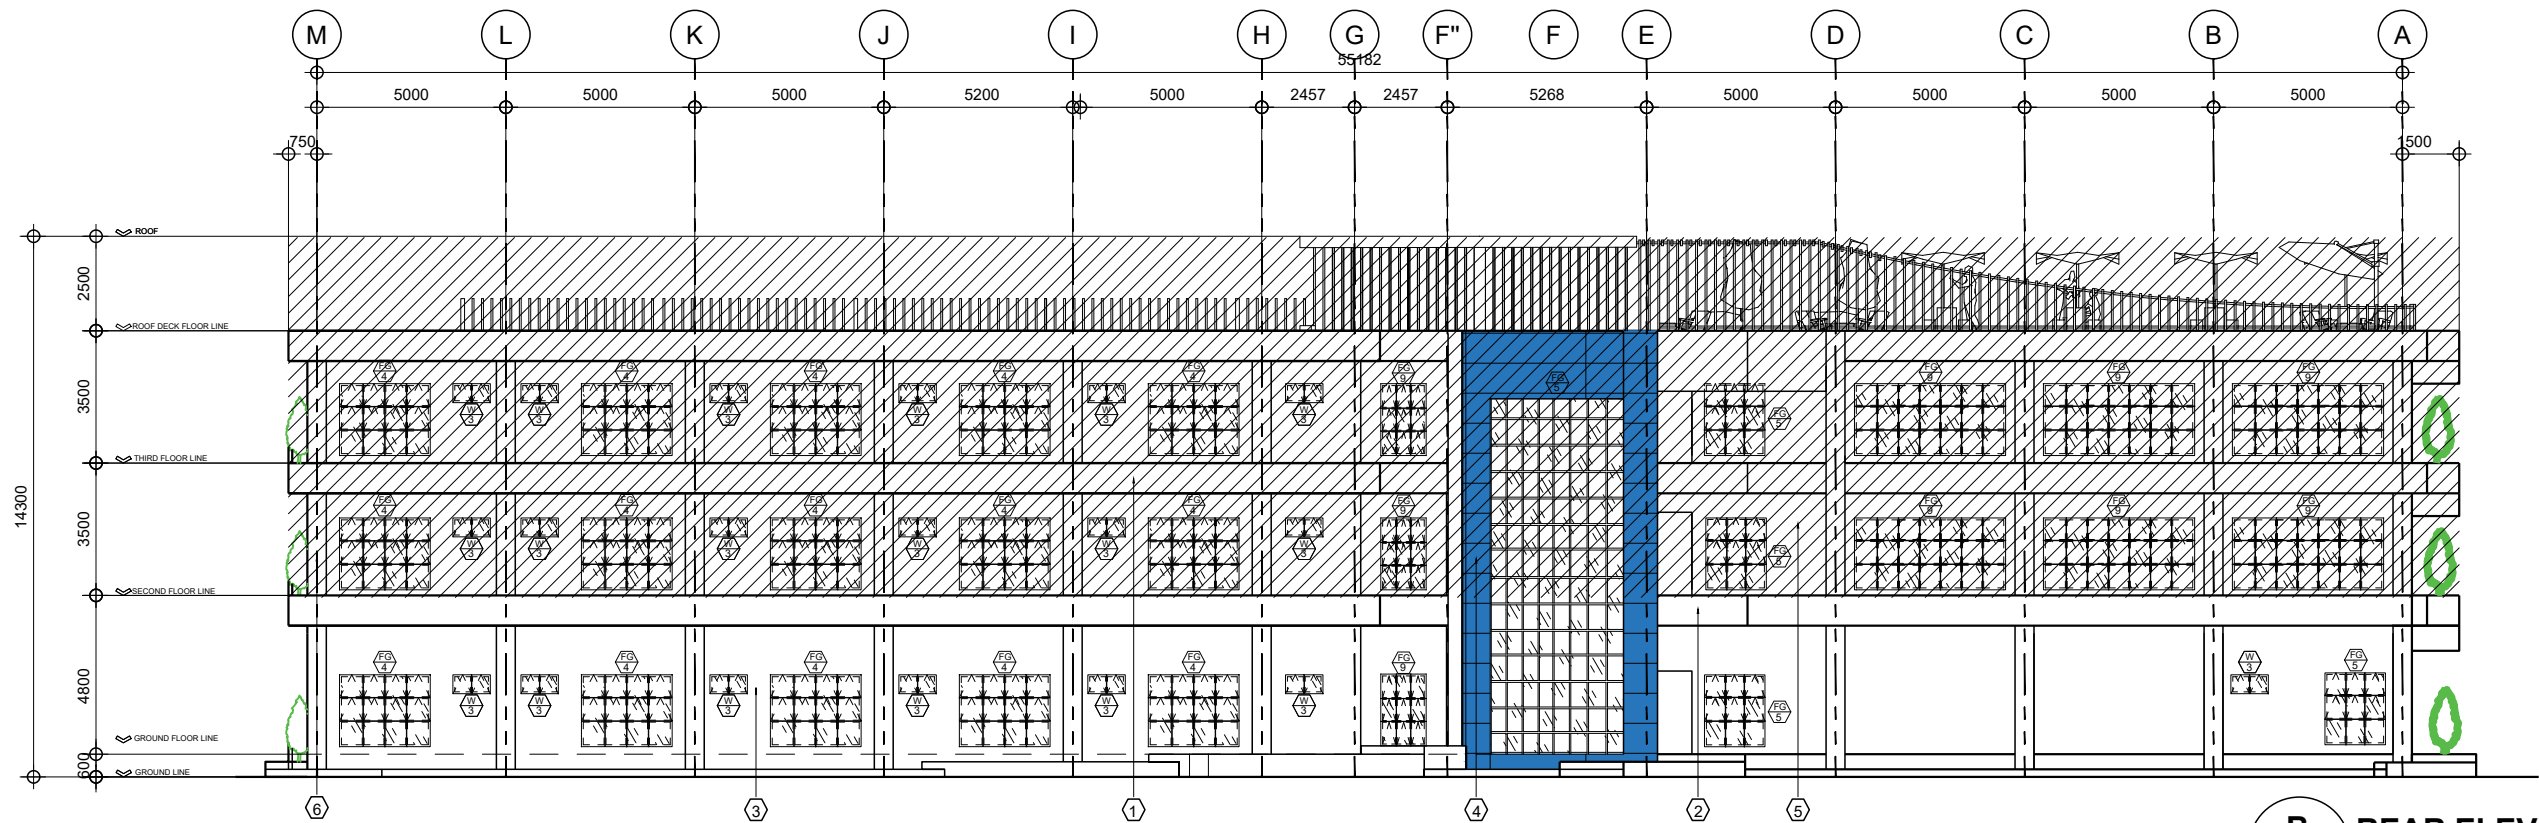

B REAR ELEVATION
A-03 SCALE 1:200M



PREPARED BY :

BYRON A. ENGASTON
 MARJORIE G. ELEJORDE
 MARK CIELO A. UYPALA
 DRAFTING AIDE-QJT

AR. JEAMES PAUL EVANGELISTA, UAP
 ARCHITECT
 ENGR. RYAN A. MACUTO, GREEN ADP+AA
 LUDIP Head Designate

PROJECT :

CONSTRUCTION OF 3-STOREY, 30 ROOMS
 APARTELLE DE SLSU PHASE I

ADDRESS: SLSU-MAIN CAMPUS, SAN ROQUE, SOGOD SOUTHERN LEYTE

OWNER :

SOUTHERN LEYTE STATE UNIVERSITY

ADDRESS: SLSU-MAIN CAMPUS, SAN ROQUE, SOGOD SOUTHERN LEYTE

APPROVED AS PER PLAN :

JUDE A. DUARTE, DPA
 UNIVERSITY PRESIDENT

SHEET CONTENT

AS SHOWN

CHECKED :
 APPROVED :


DRAWN :
 DATE :

SCALE
 AS SHOWN @ 20x30


SHEET NO.

A-03


PROJ. NO.

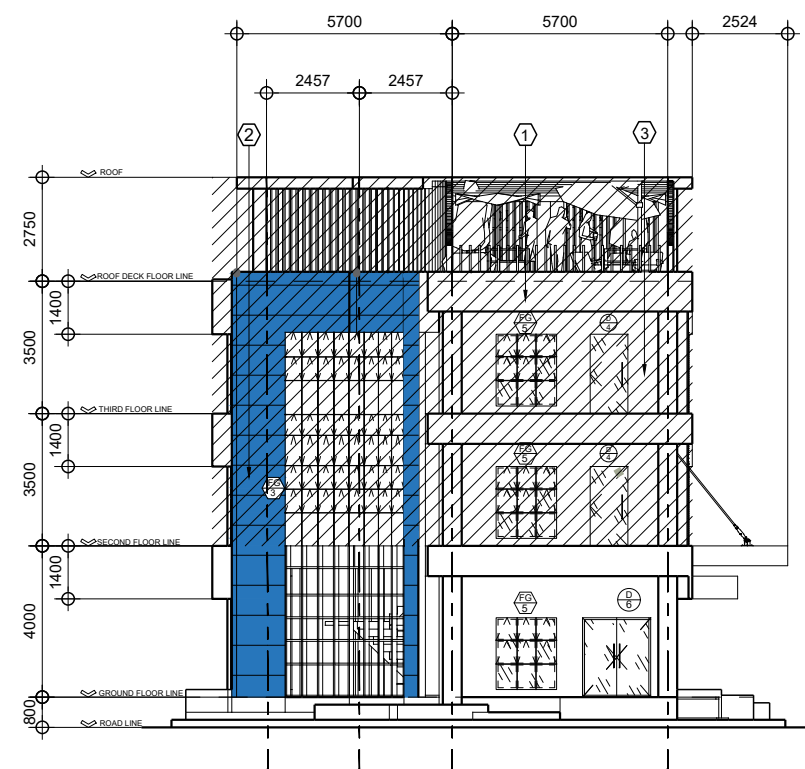

A LEFT ELEVATION

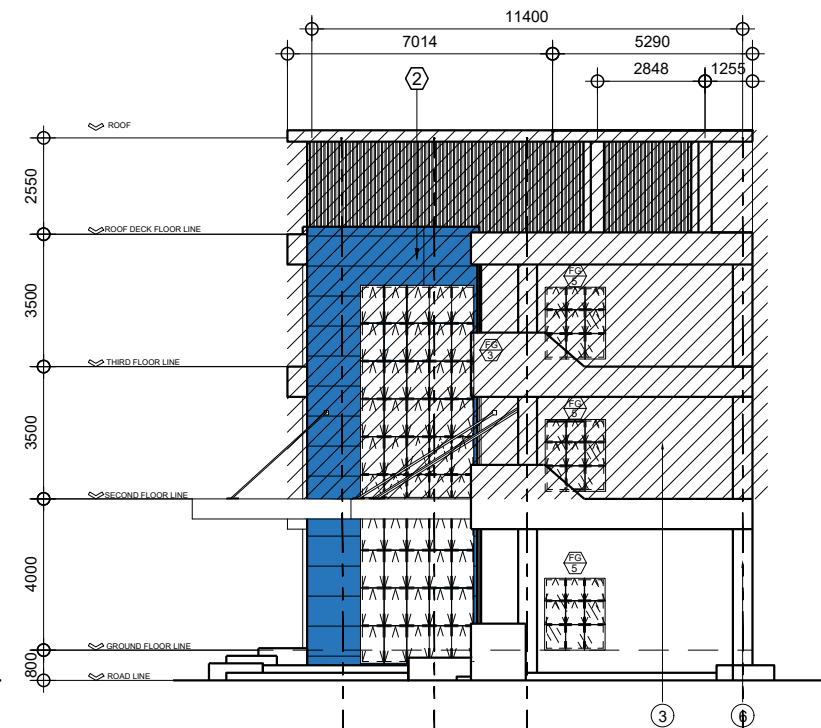


B RIGHT ELEVATION
A-04 SCALE 1:200M

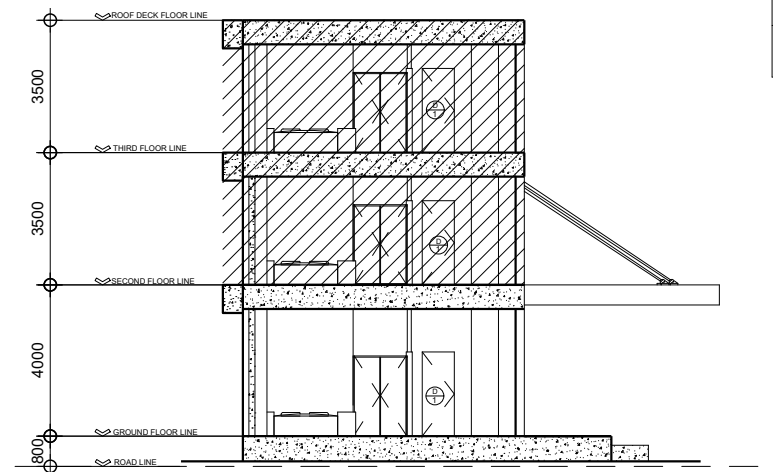


B **CROSS SECTION**
A-04 SCALE 1:200M

LEGEND:	
	Satin Paint Finish White (Top Coat)
	ALUMINUM COMPOSITE PANEL (BLUE)
	Satin Paint Finish White (Top Coat)
	ALUMINUM COMPOSITE PANEL (BLUE)
	Textured Paint Finish Beige (Accent Coat)
	Satin Paint Finish Steel Gray (Accent Coat)
	Satin Paint Finish Steel Gray (Accent Coat)


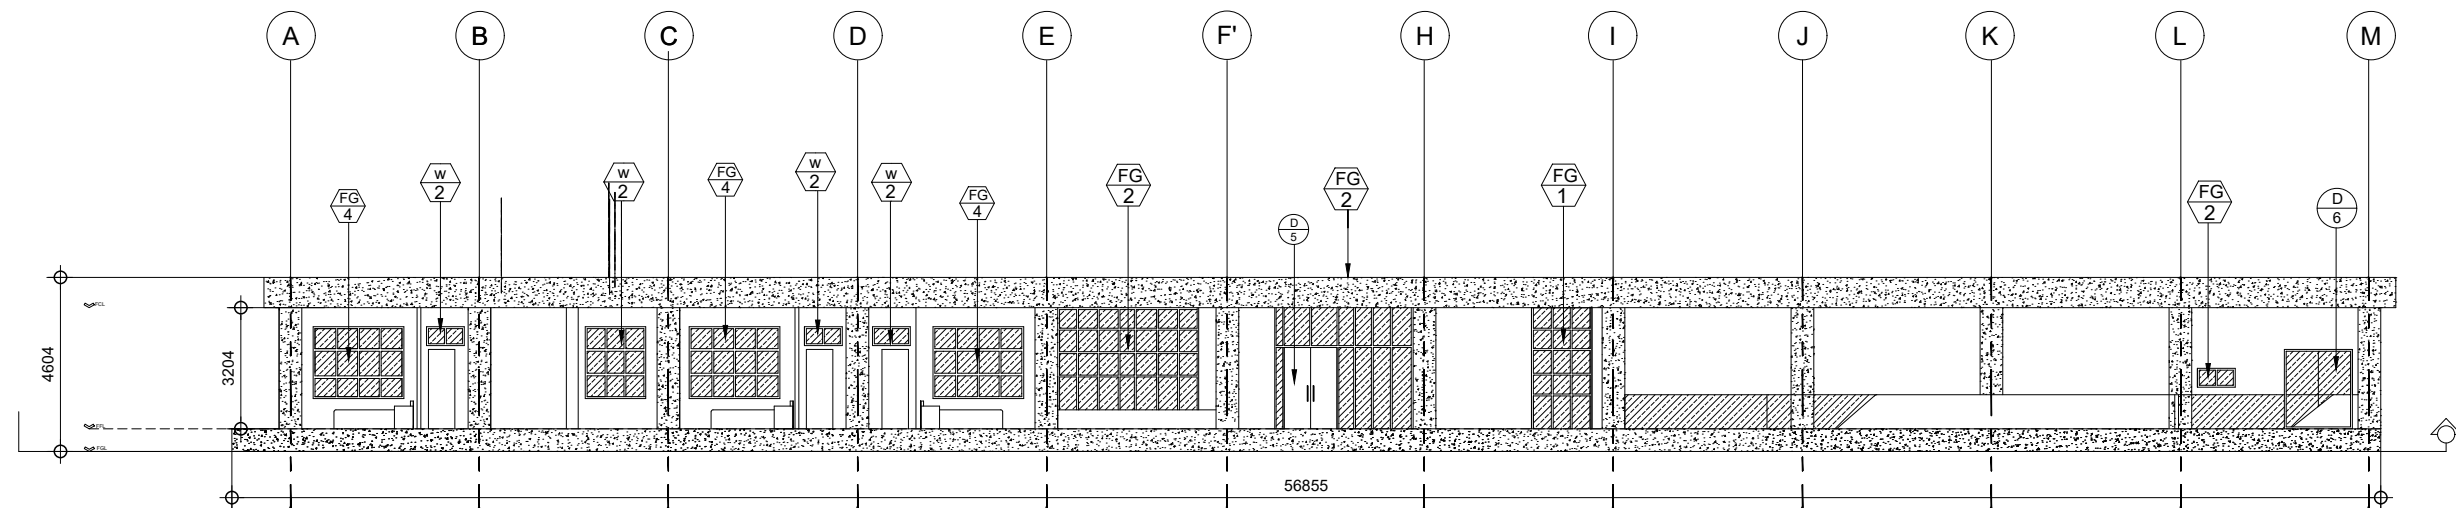


D A-04 GROUND FLOOR LONGITUDINAL SECTION SCALE 1:200M

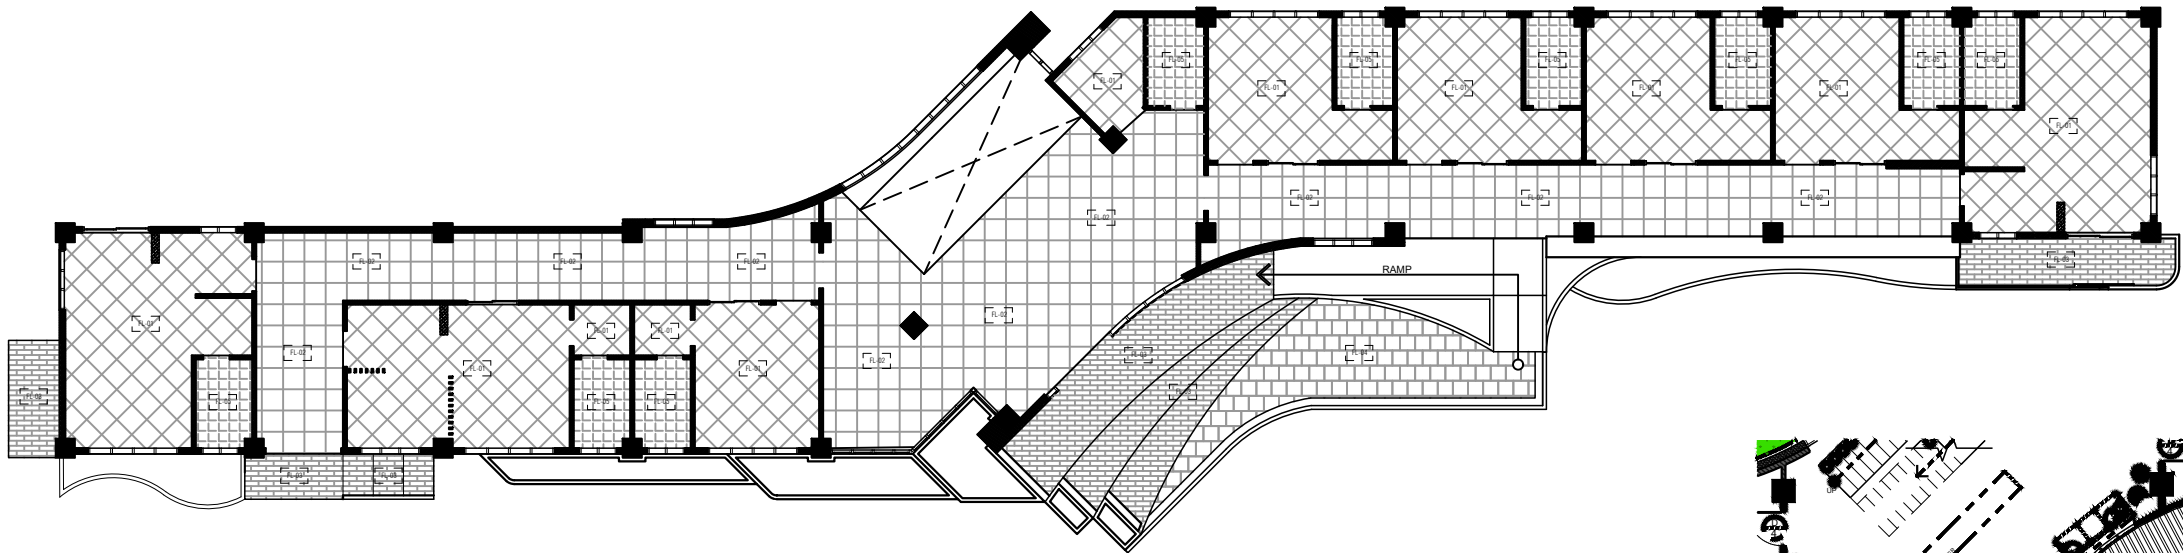


FLOOR LEGENDS			
CODE	SYMBOL	LOCATION	DESCRIPTION
FL-01		ROOMS, UNITS & EE ROOM	0.60m x 0.60m SUPER WHITE POLISHED PORCELAIN FLOOR TILES (SEE SPECS)
FL-02		LOBBY & HALLWAY	0.60m x 0.60m BEIGE POLISHED PORCELAIN FLOOR TILES (SEE SPECS)
FL-03		ENTRANCE/EXIT (OUTDOOR STAIRS) & TERRACE (UNIT 103)	0.60m x 0.60m BASALT MATTE PORCELAIN FLOOR TILES (SEE SPECS)
FL-04		ENTRANCE (NAT. GRD. LVL.)	0.60m x 0.60m NON-SLIP BASALT PORCELAIN FLOOR TILES (SEE SPECS)
FL-05		T&B	0.60m x 0.60m NON-SLIP GRAY PORCELAIN FLOOR TILES (SEE SPECS)


A TILES LAYOUT PLAN
A-05 SCALE 1:200M

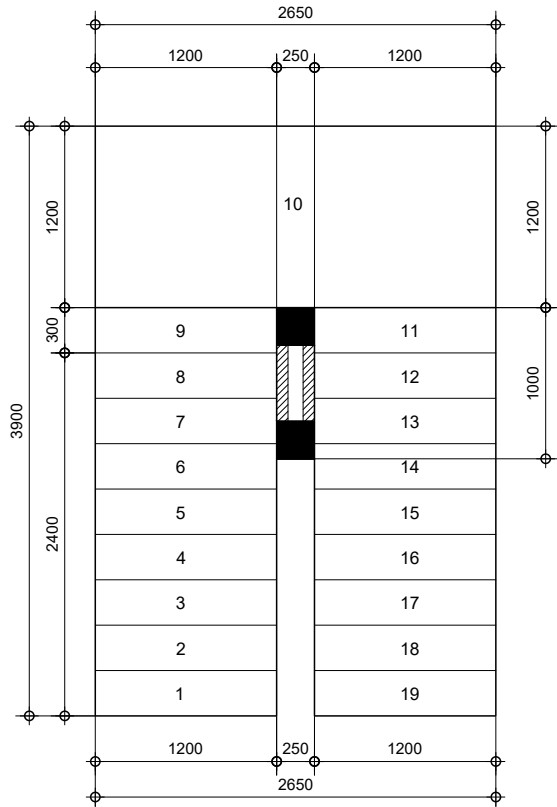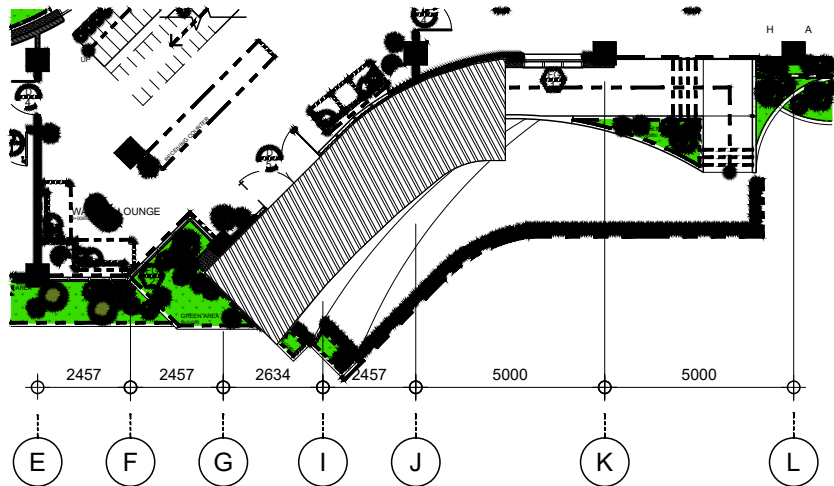

B GROUND FLOOR LEVEL STAIRS
A-05 SCALE 1:50M

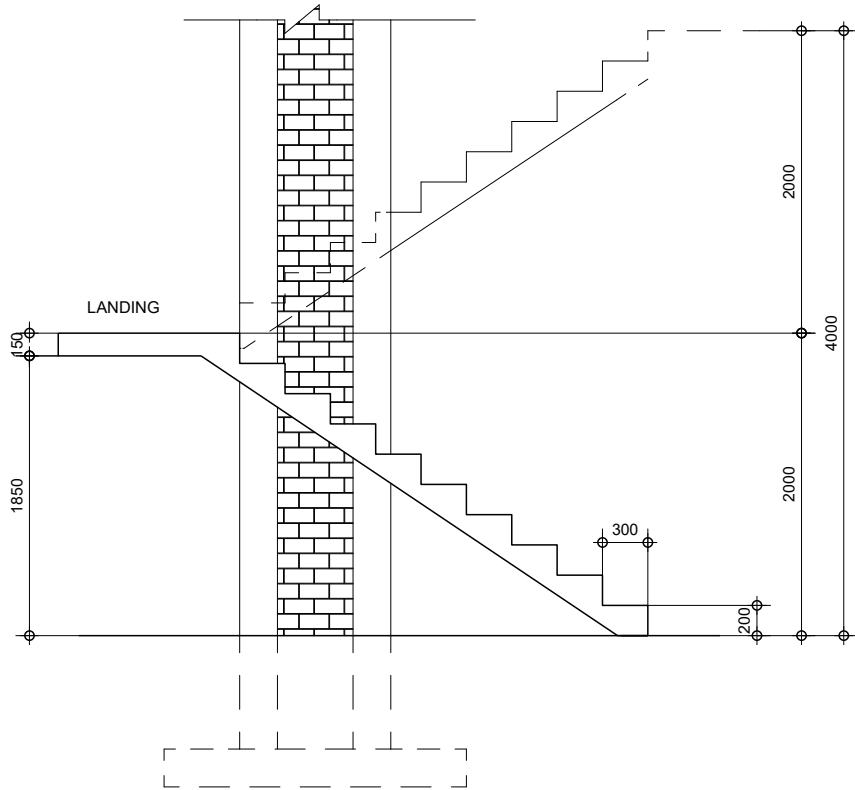

C TEMPORARY CANOPY (ENTRANCE)
A-05 SCALE NTS

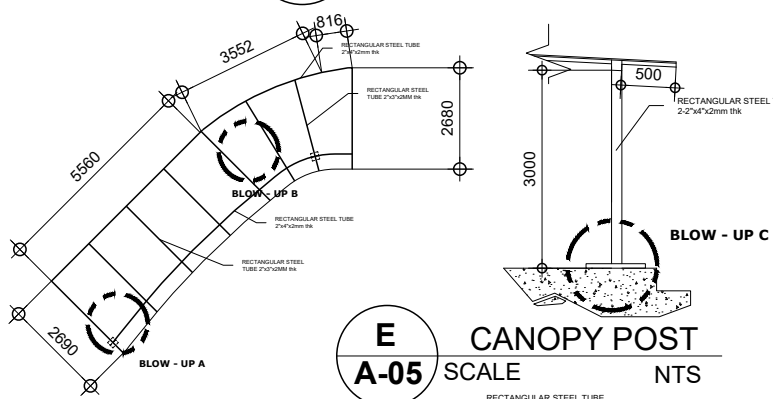


E CANOPY POST
A-05 SCALE NTS

D CANOPY FRAMING
A-05 SCALE NTS


G BLOW - UP DETAIL "C"
A-05 SCALE NTS

F BLOW - UP DETAIL "A"
A-05 SCALE NTS

H BLOW - UP DETAIL "B"
A-05 SCALE NTS

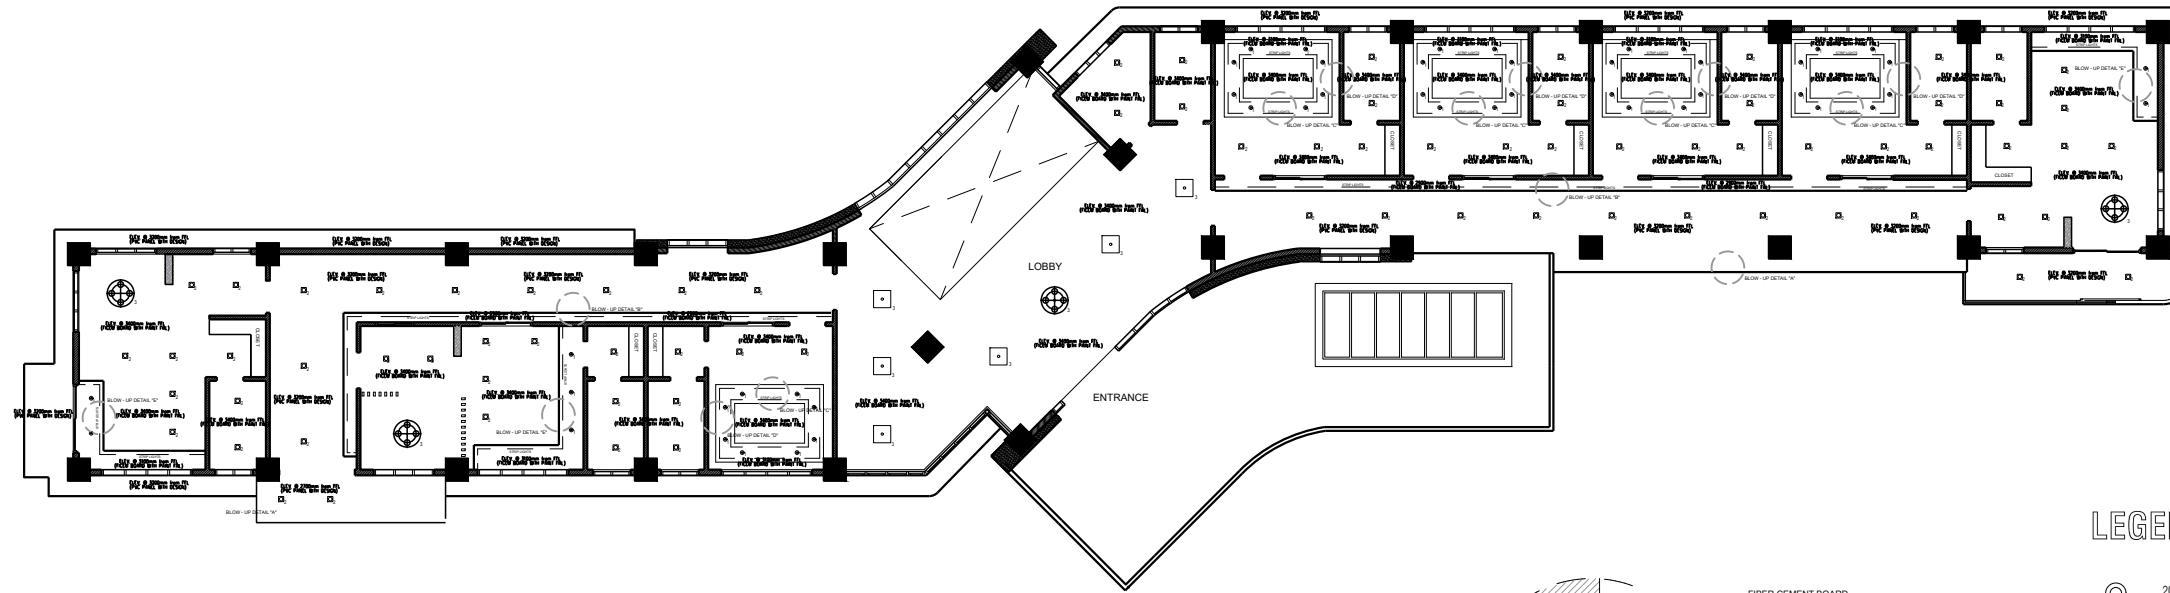


A CEILING PLAN
A-06 SCALE 1:200M

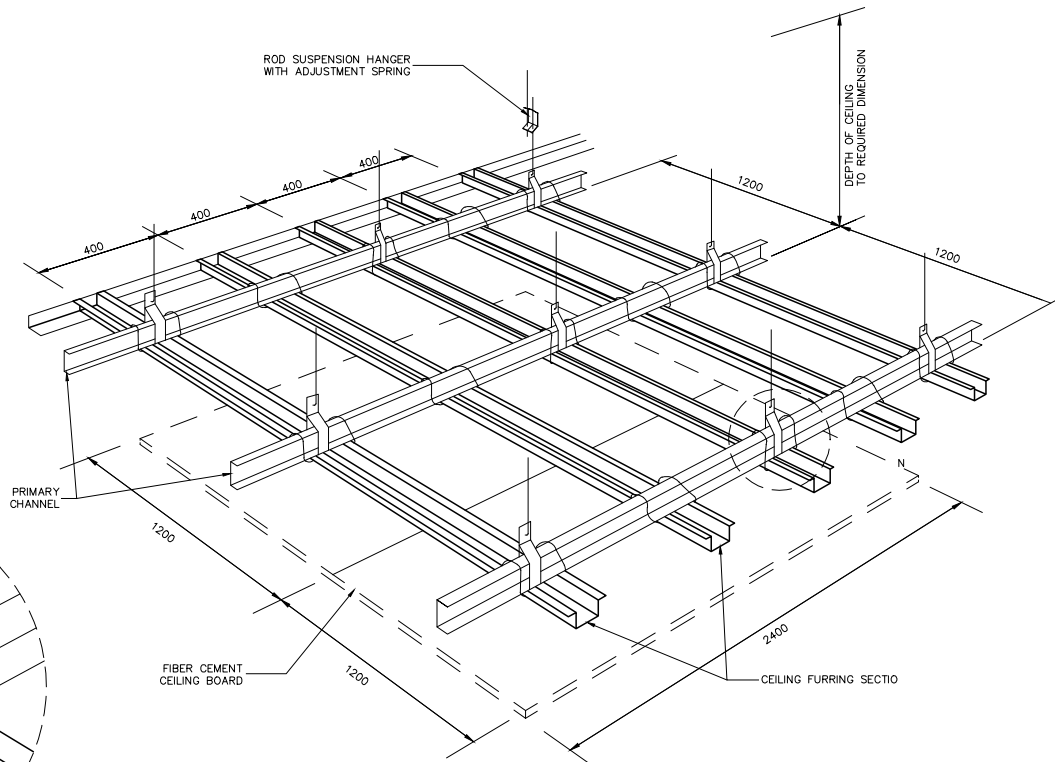


PERSPECTIVE (CEILING)

NTS

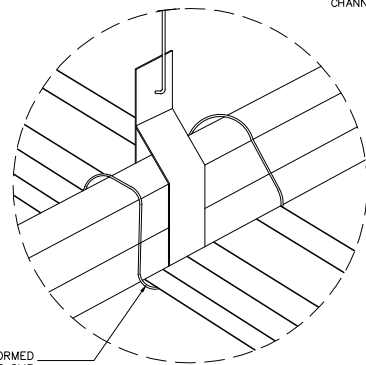


SPOT DETAIL

NTS

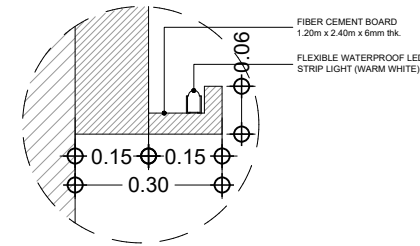


BLOW - UP DETAIL "B"

NTS

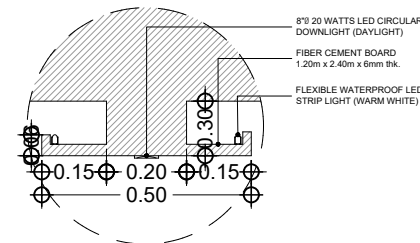


BLOW - UP DETAIL "C"

NTS

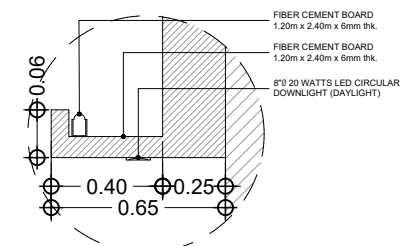


BLOW - UP DETAIL "E"

NTS

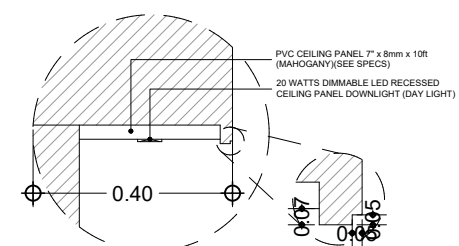

BLOW - UP DETAIL "A"

NTS

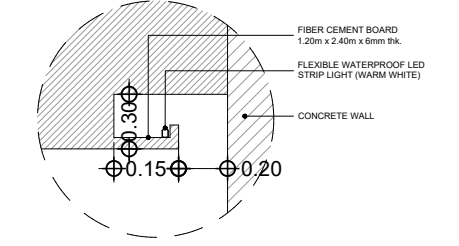


BLOW - UP DETAIL "D"

NTS


LEGEND & SYMBOLS

- 20 WATTS LED CIRCULAR DOWNLIGHT 8"Ø (DAYLIGHT)
- 20 WATTS DIMMABLE LED RECESSED CEILING PANEL DOWNLIGHT (DAYLIGHT)
- 36 WATTS FLUSH MOUNTED LED PANEL LIGHT, 595mm x 595mm x 10mm(DAYLIGHT)
- CHANDELIER


PREPARED BY :			PROJECT :	OWNER :	APPROVED AS PER PLAN :	SHEET CONTENT		SHEET NO.
BYRON A. ENGASTON	MARJORIE G. ELEJORDE	MARK CIELO A. UYPALA	CONSTRUCTION OF 3-STOREY, 30 ROOMS APARTELLE DE SLSU PHASE I ADDRESS: SLSU-MAIN CAMPUS, SAN ROQUE, SOGOD SOUTHERN LEYTE	SOUTHERN LEYTE STATE UNIVERSITY ADDRESS: SLSU-MAIN CAMPUS, SAN ROQUE, SOGOD SOUTHERN LEYTE	JUDE A. DUARTE, DPA UNIVERSITY PRESIDENT	AS SHOWN		A-06
DRAFTING AIDE-QJT	AR. JEAMES PAUL EVANGELISTA, UAP ARCHITECT	ENGR. RYAN A. MACUTO, GREEN ADP+AA LUDIP Head Designate				CHECKED : APPROVED :	DRAWN : DATE :	
						SCALE AS SHOWN @ 20x30	PROJ. NO.	

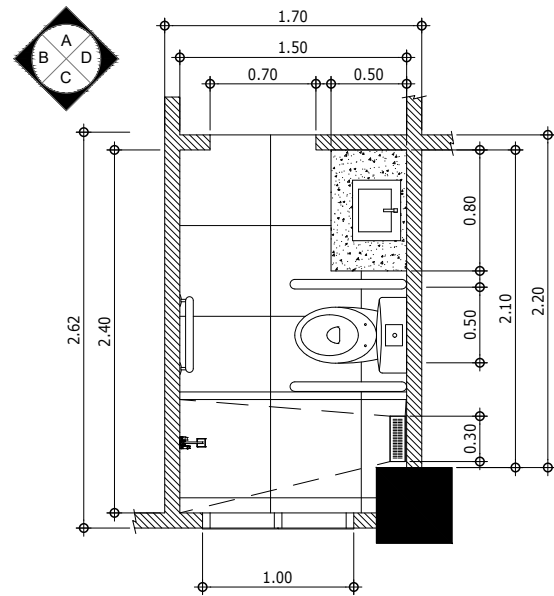


PLAN
A (T&B - UNIT 101 & ROOM 101)
A-07 SCALE 1:50M

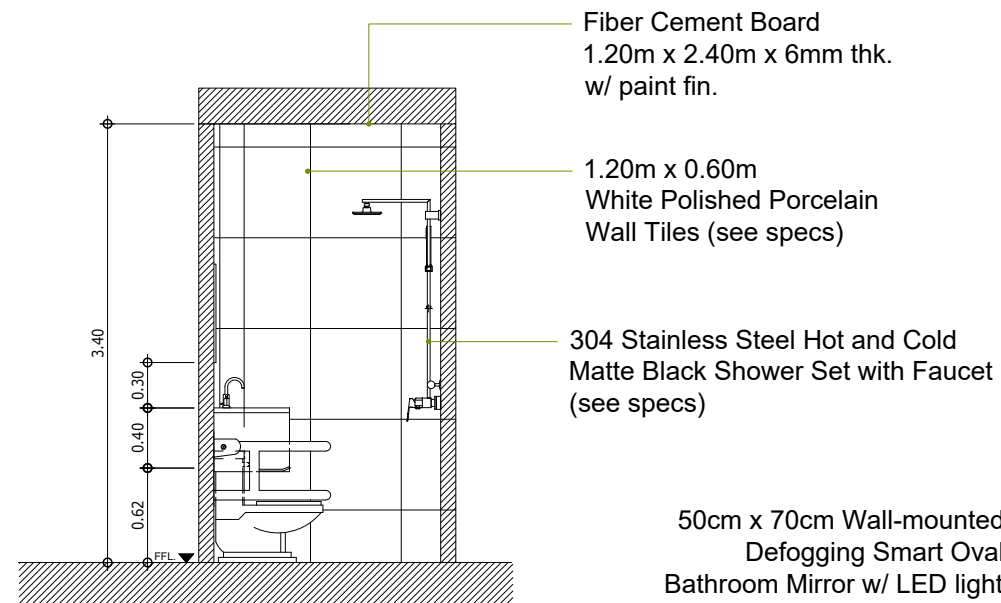


D (T&B - UNIT 101 & ROOM 101)
A-07 SECTION - ELEVATION "C"
SCALE 1:50M

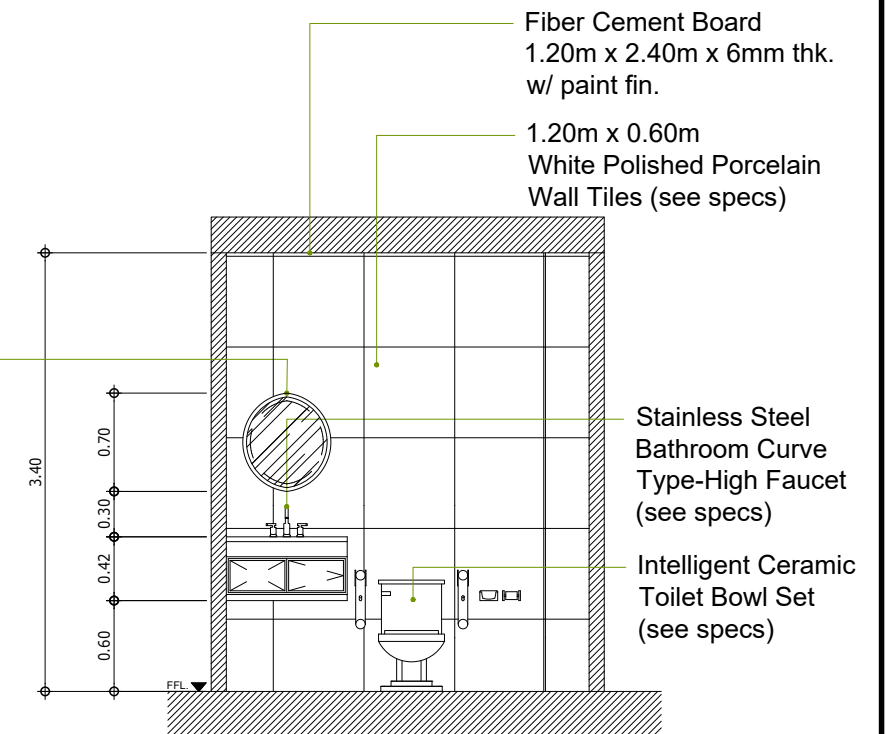

E (T&B - UNIT 101 & ROOM 101)
A-07 SECTION - ELEVATION "D"
SCALE 1:50M

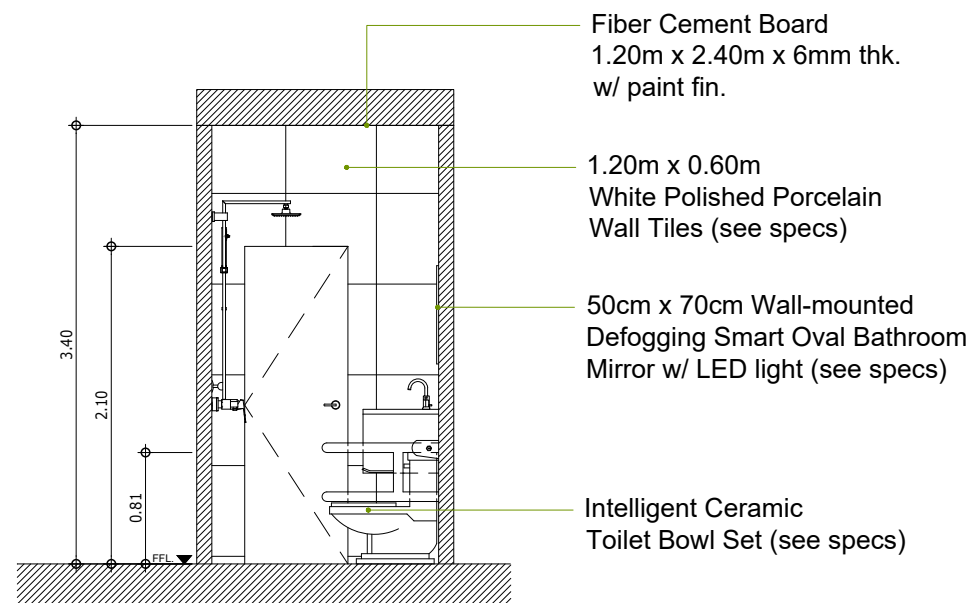


B (T&B - UNIT 101 & ROOM 101)
A-07 SECTION - ELEVATION "A"
SCALE 1:50M

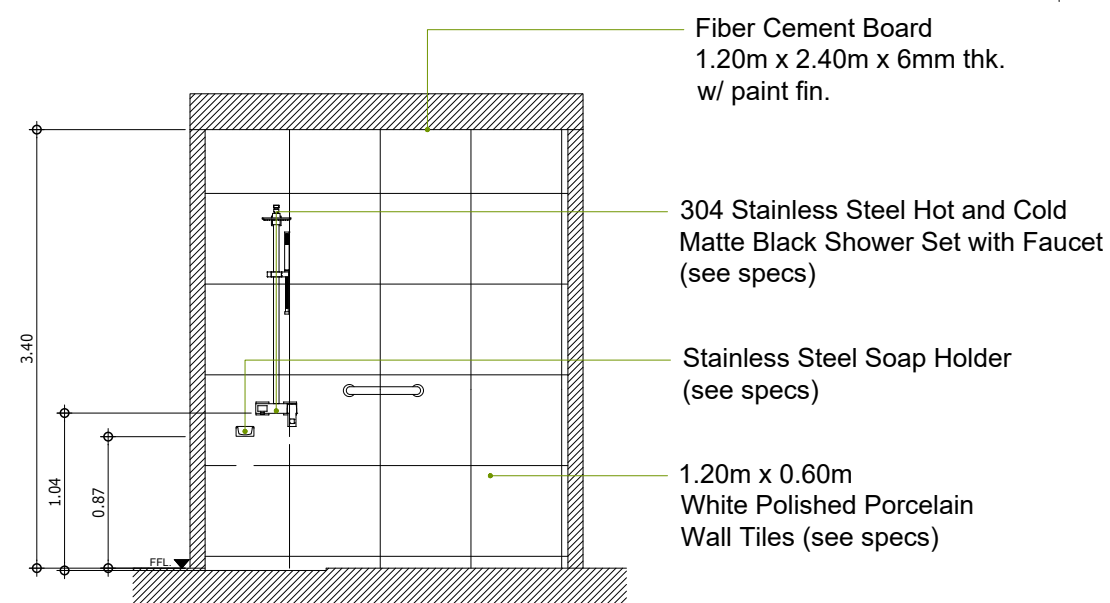


C (T&B - UNIT 101 & ROOM 101)
A-07 SECTION - ELEVATION "B"
SCALE 1:50M


SOUTHERN LEYTE STATE UNIVERSITY Main Campus, San Roque, Sogod, Southern Leyte Email: president@southernleytestateu.edu.ph Website: www.southernleytestateu.edu.ph	PREPARED BY :		PROJECT :	OWNER :	APPROVED AS PER PLAN :	SHEET CONTENT	SHEET NO.
	BYRON A. ENGASTON	AR. JEAMES PAUL EVANGELISTA, UAP	CONSTRUCTION OF 3-STOREY, 30 ROOMS APARTELLE DE SLSU PHASE I	SOUTHERN LEYTE STATE UNIVERSITY	JUDE A. DUARTE, DPA UNIVERSITY PRESIDENT	AS SHOWN	A-07
	MARJORIE G. ELEJORDE	ARCHITECT					
	MARK CIELO A. UYPALA	ENGR. RYAN A. MACUTO, GREEN ADP+AA					
Excellence Service Leadership and Good Governance Innovation Social Responsibility Integrity Professionalism Spirituality	DRAFTING AIDE-QJT	LUDIP Head Designate	ADDRESS: SLSU-MAIN CAMPUS, SAN ROQUE, SOGOD SOUTHERN LEYTE	ADDRESS: SLSU-MAIN CAMPUS, SAN ROQUE, SOGOD SOUTHERN LEYTE		CHECKED : APPROVED :	SCALE AS SHOWN @ 20x30 PROJ. NO.

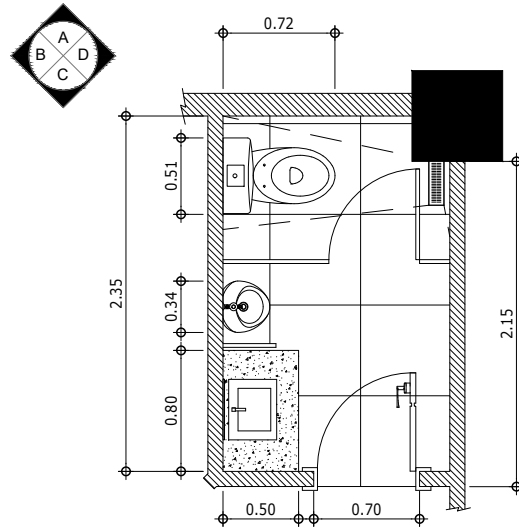


A PLAN (COMMON C.R.)
A-08 SCALE 1:50M

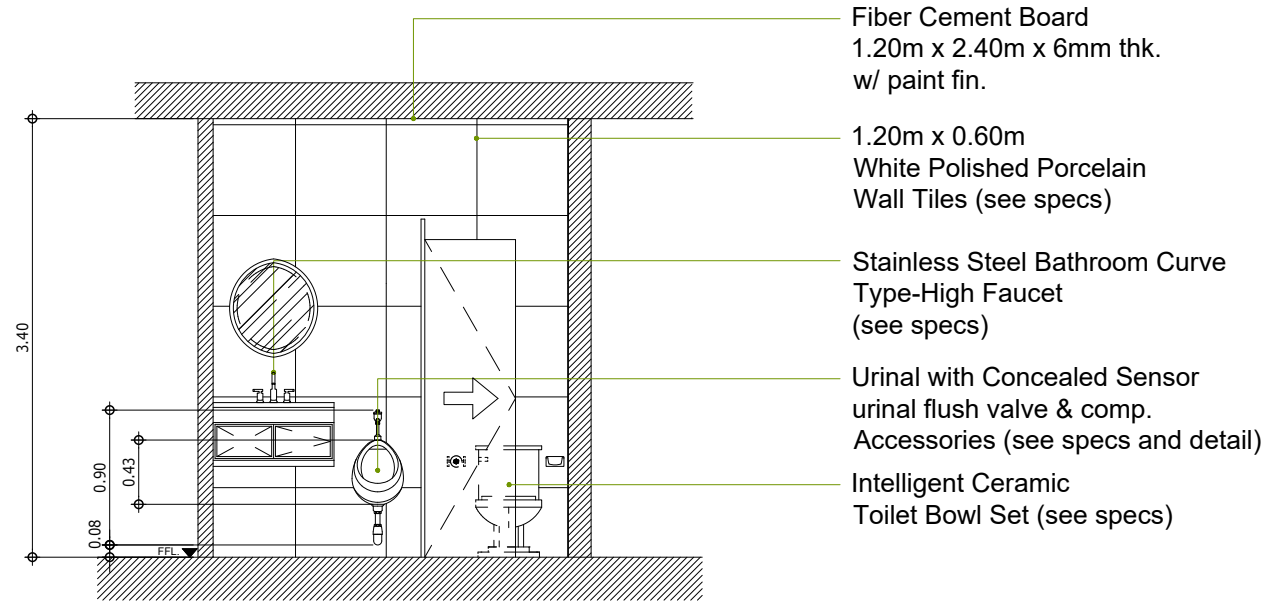


(COMMON C.R.)
C SECTION - ELEVATION "B"
A-08 SCALE 1:50M

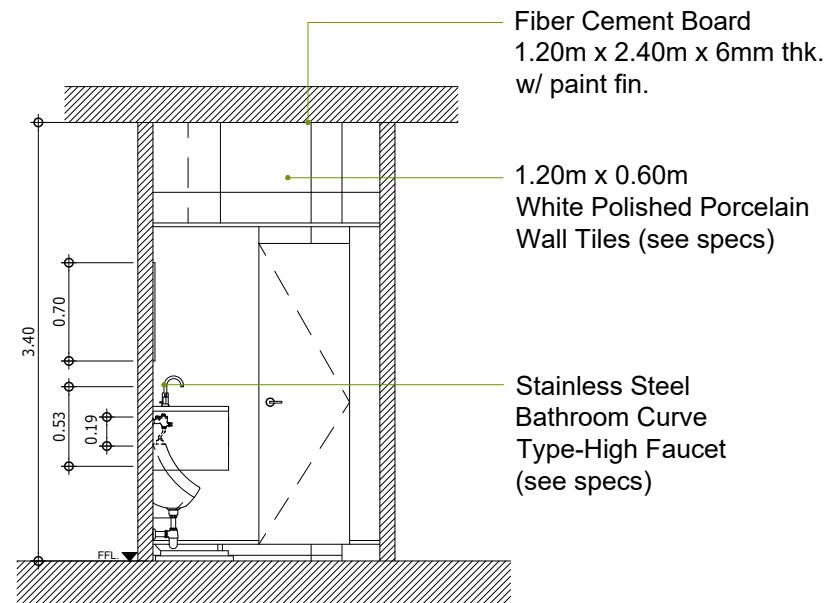


(COMMON C.R.)
B SECTION - ELEVATION "A"
A-08 SCALE 1:50M

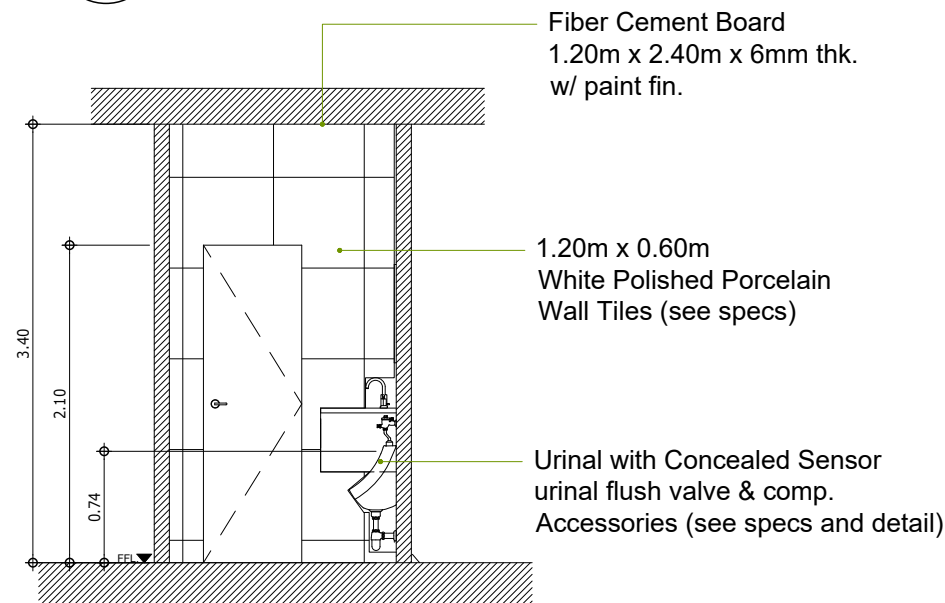


(COMMON C.R.)
D SECTION - ELEVATION "C"
A-08 SCALE 1:50M

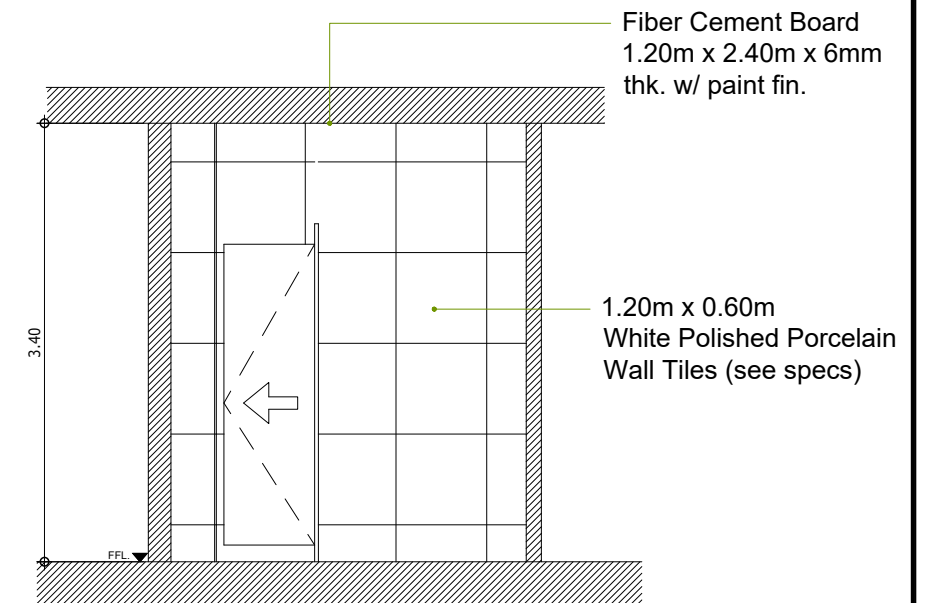

(COMMON C.R.)
E SECTION - ELEVATION "D"
A-08 SCALE 1:50M

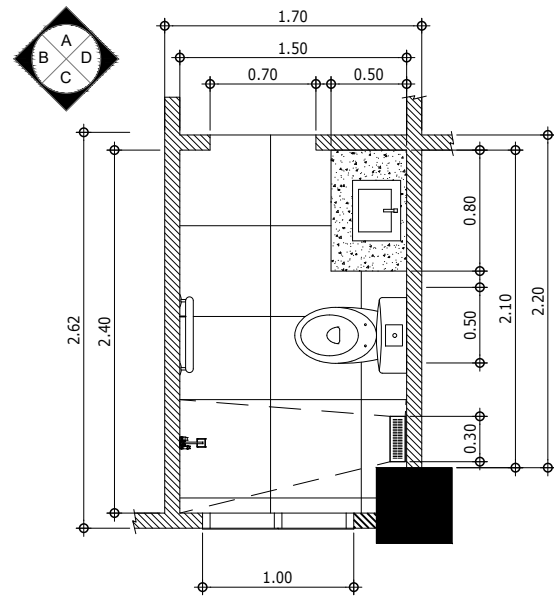

PLAN
A (T&B - ROOMS & UNIT 102-103)
A-09 SCALE 1:50M

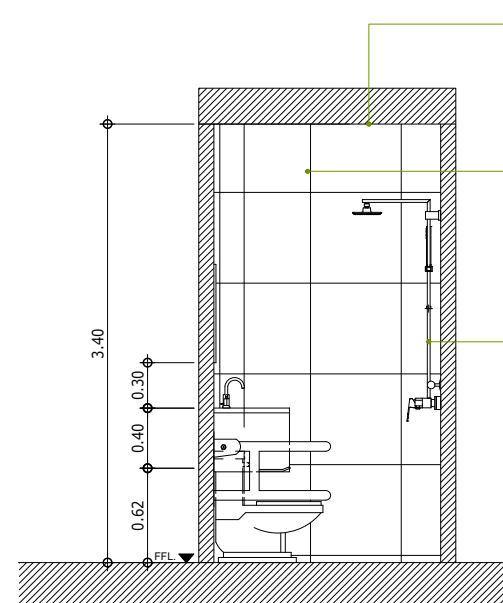


(T&B - UNIT 101 & ROOM 101)
D **SECTION - ELEVATION "C"**
A-07 SCALE 1:50M

Fiber Cement Board
1.20m x 2.40m x 6mm thk.
w/ paint fin.

1.20m x 0.60m
White Polished Porcelain
Wall Tiles (see specs)

304 Stainless Steel Hot and Cold
Matte Black Shower Set with Faucet
(see specs)

50cm x 70cm Wall-mounted
Defogging Smart Oval
Bathroom Mirror w/ LED light
(see specs)

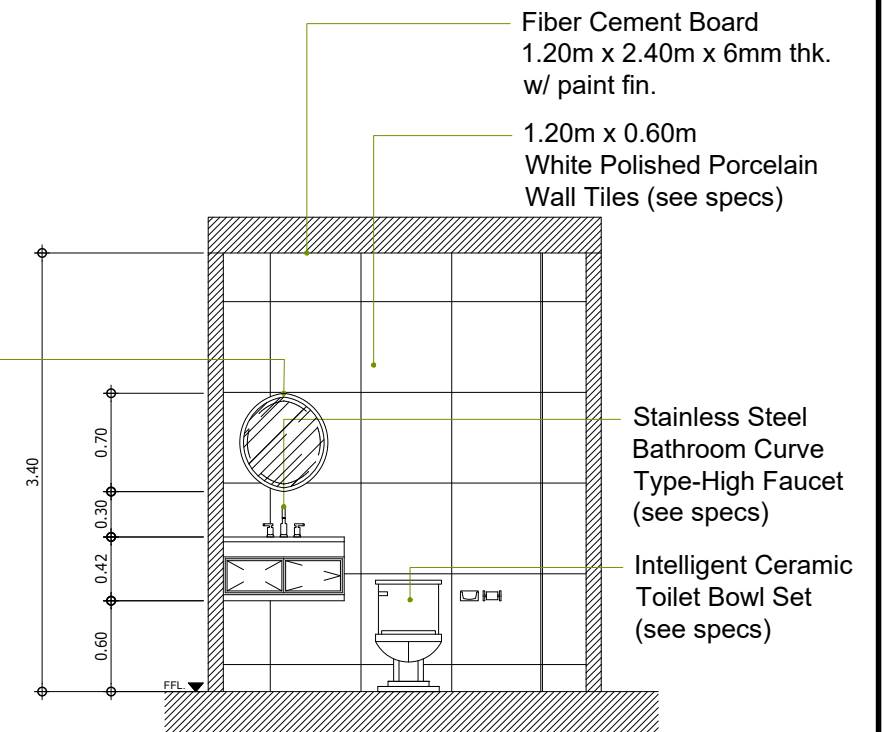


(T&B - UNIT 101 & ROOM 101)
E **SECTION - ELEVATION "D"**
A-07 SCALE 1:50M

Fiber Cement Board
1.20m x 2.40m x 6mm thk.
w/ paint fin.

1.20m x 0.60m
White Polished Porcelain
Wall Tiles (see specs)

Stainless Steel
Bathroom Curve
Type-High Faucet
(see specs)

Intelligent Ceramic
Toilet Bowl Set
(see specs)

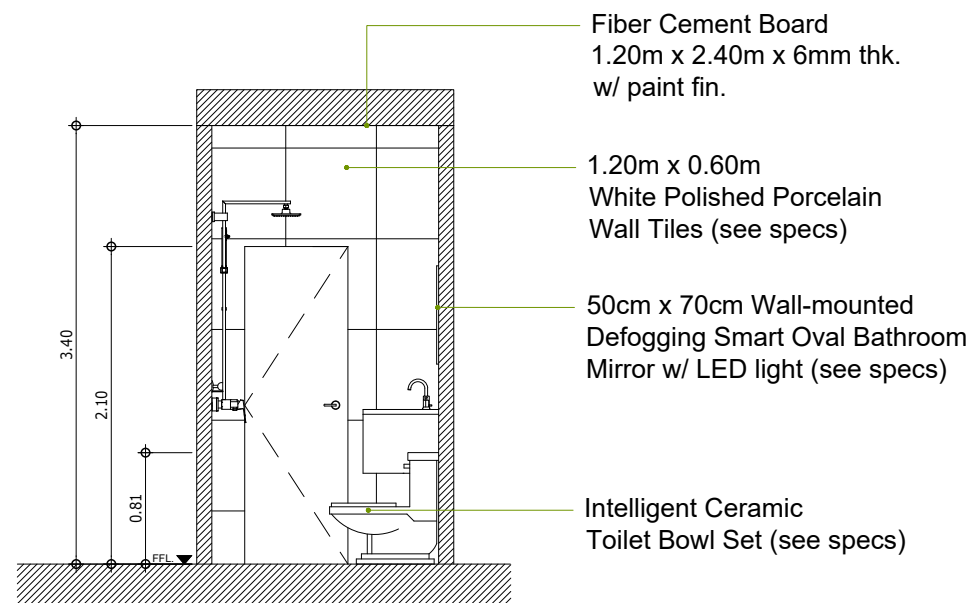


(T&B - UNIT 101 & ROOM 101)
B **SECTION - ELEVATION "A"**
A-07 SCALE 1:50M

Fiber Cement Board
1.20m x 2.40m x 6mm thk.
w/ paint fin.

1.20m x 0.60m
White Polished Porcelain
Wall Tiles (see specs)

50cm x 70cm Wall-mounted
Defogging Smart Oval Bathroom
Mirror w/ LED light (see specs)

Intelligent Ceramic
Toilet Bowl Set (see specs)

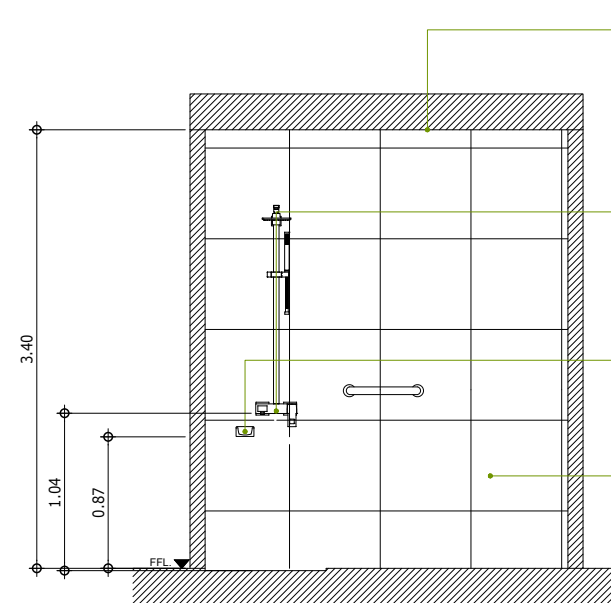



(T&B - UNIT 101 & ROOM 101)
C **SECTION - ELEVATION "B"**
A-07 SCALE 1:50M

Fiber Cement Board
1.20m x 2.40m x 6mm thk.
w/ paint fin.

304 Stainless Steel Hot and Cold
Matte Black Shower Set with Faucet
(see specs)

Stainless Steel Soap Holder
(see specs)


1.20m x 0.60m
White Polished Porcelain
Wall Tiles (see specs)

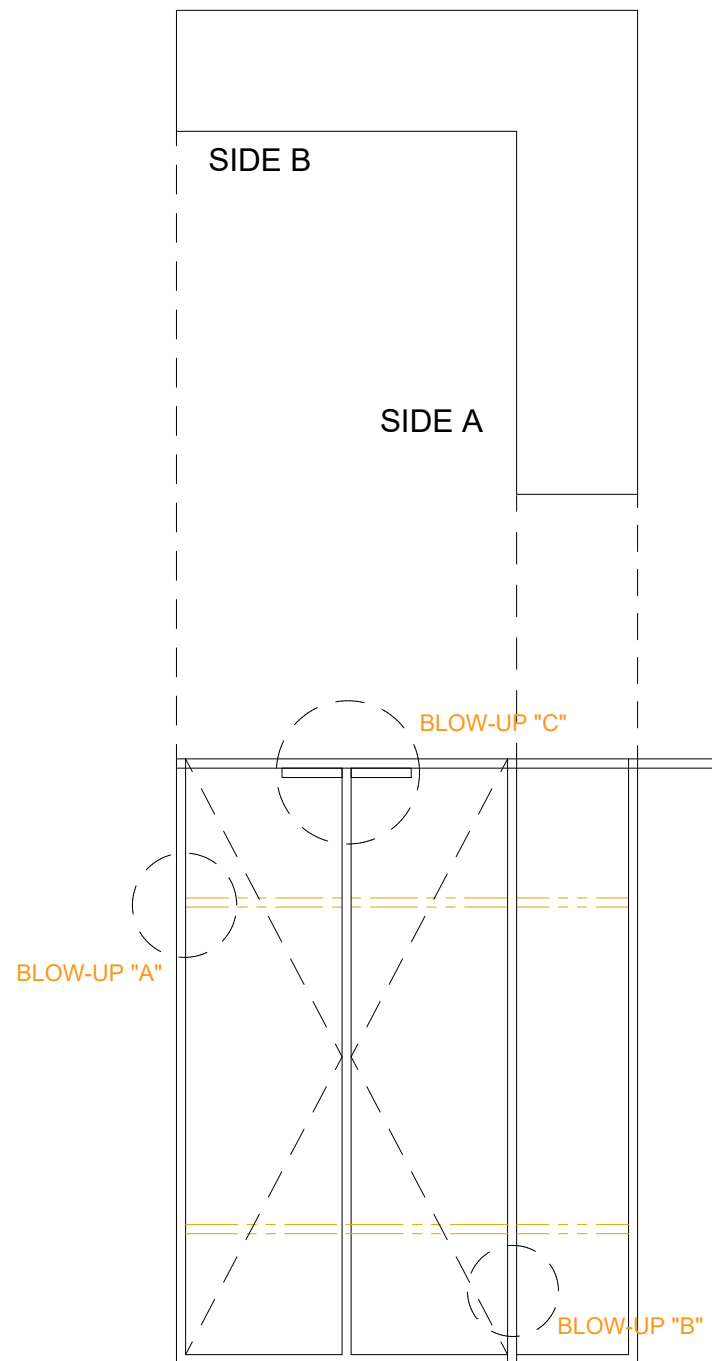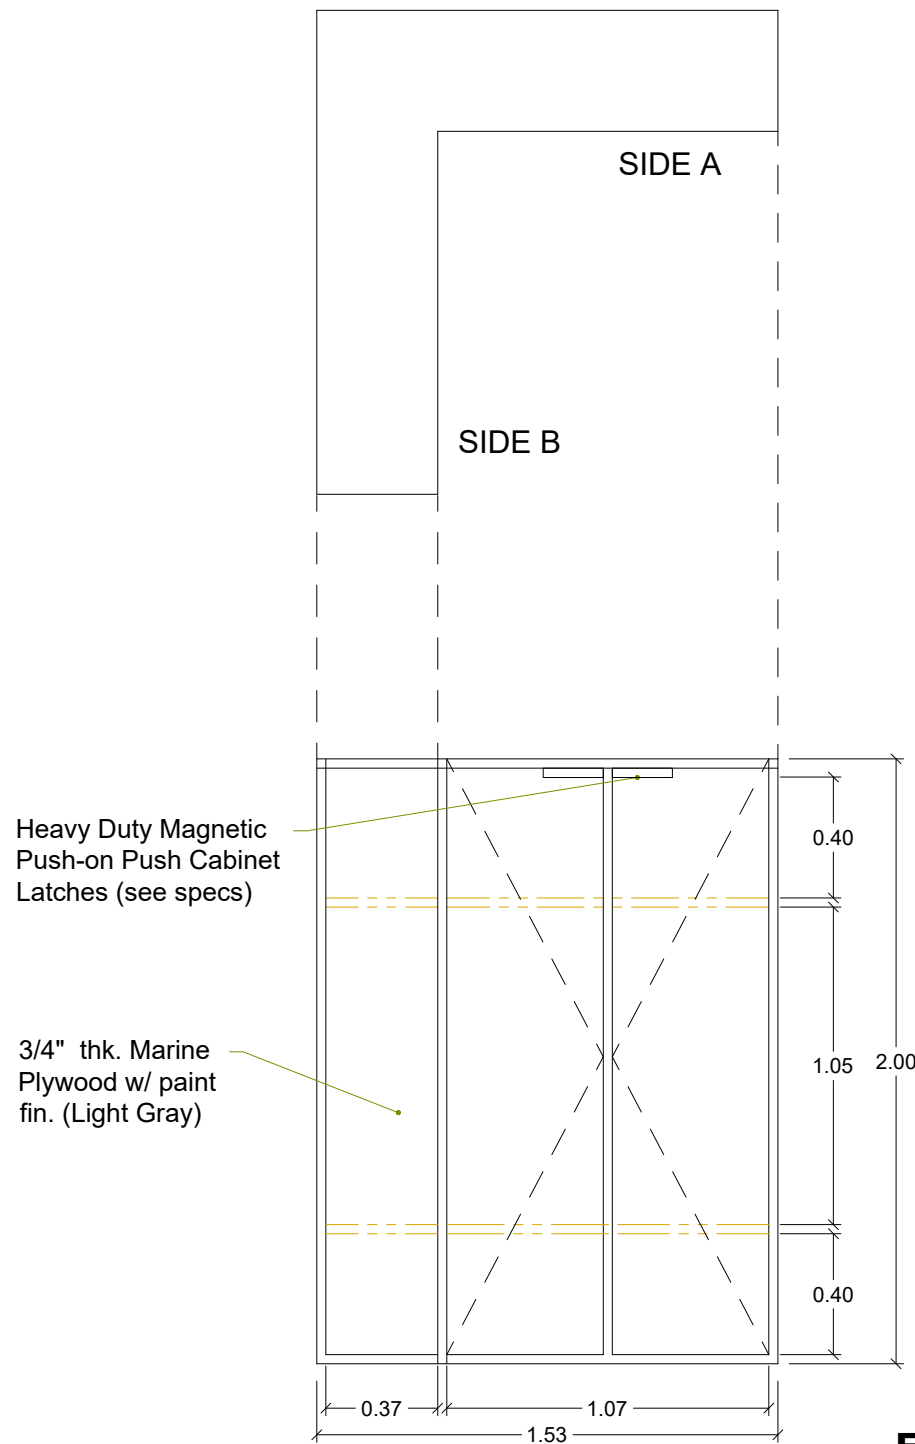

FRONT VIEW


SIDE VIEW

A
A-10 UNIT CLOSETS DETAILS
SCALE NTS.

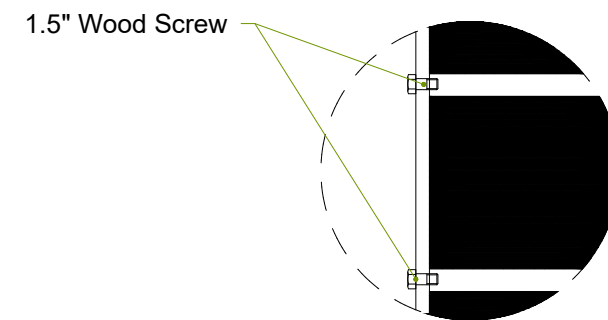


B
A-10 BLOW-UP DETAIL "A"
SCALE NTS.

Hydraulic concealed cabinet hinges (see specs)

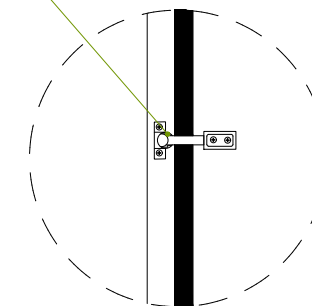


C
A-10 BLOW-UP DETAIL "B"
SCALE NTS.

Heavy Duty Magnetic Push-on Push Cabinet Latches (see specs)

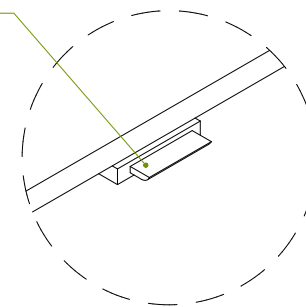


D
A-10 BLOW-UP DETAIL "C"
SCALE NTS.

 SOUTHERN LEYTE STATE UNIVERSITY Main Campus, San Roque, Sogod, Southern Leyte Email: president@southernleytestateu.edu.ph Website: www.southernleytestateu.edu.ph Excellence Service Leadership and Good Governance Innovation Social Responsibility Integrity Professionalism Spirituality	PREPARED BY :		PROJECT :	OWNER :	APPROVED AS PER PLAN :	SHEET CONTENT	SHEET NO.
	BYRON A. ENGASTON	AR. JEAMES PAUL EVANGELISTA, UAP	CONSTRUCTION OF 3-STOREY, 30 ROOMS APARTELLE DE SLSU PHASE I	SOUTHERN LEYTE STATE UNIVERSITY	JUDE A. DUARTE, DPA UNIVERSITY PRESIDENT	AS SHOWN	A-10
	MARJORIE G. ELEJORDE	ARCHITECT					
	MARK CIELO A. UYPALA	ENGR. RYAN A. MACUTO, GREEN ADP+AA					
	DRAFTING AIDE-QJT	LUDIP Head Designate	ADDRESS: SLSU-MAIN CAMPUS, SAN ROQUE, SOGOD SOUTHERN LEYTE	ADDRESS: SLSU-MAIN CAMPUS, SAN ROQUE, SOGOD SOUTHERN LEYTE		CHECKED : APPROVED :	SCALE AS SHOWN @ 20x30 PROJ. NO.

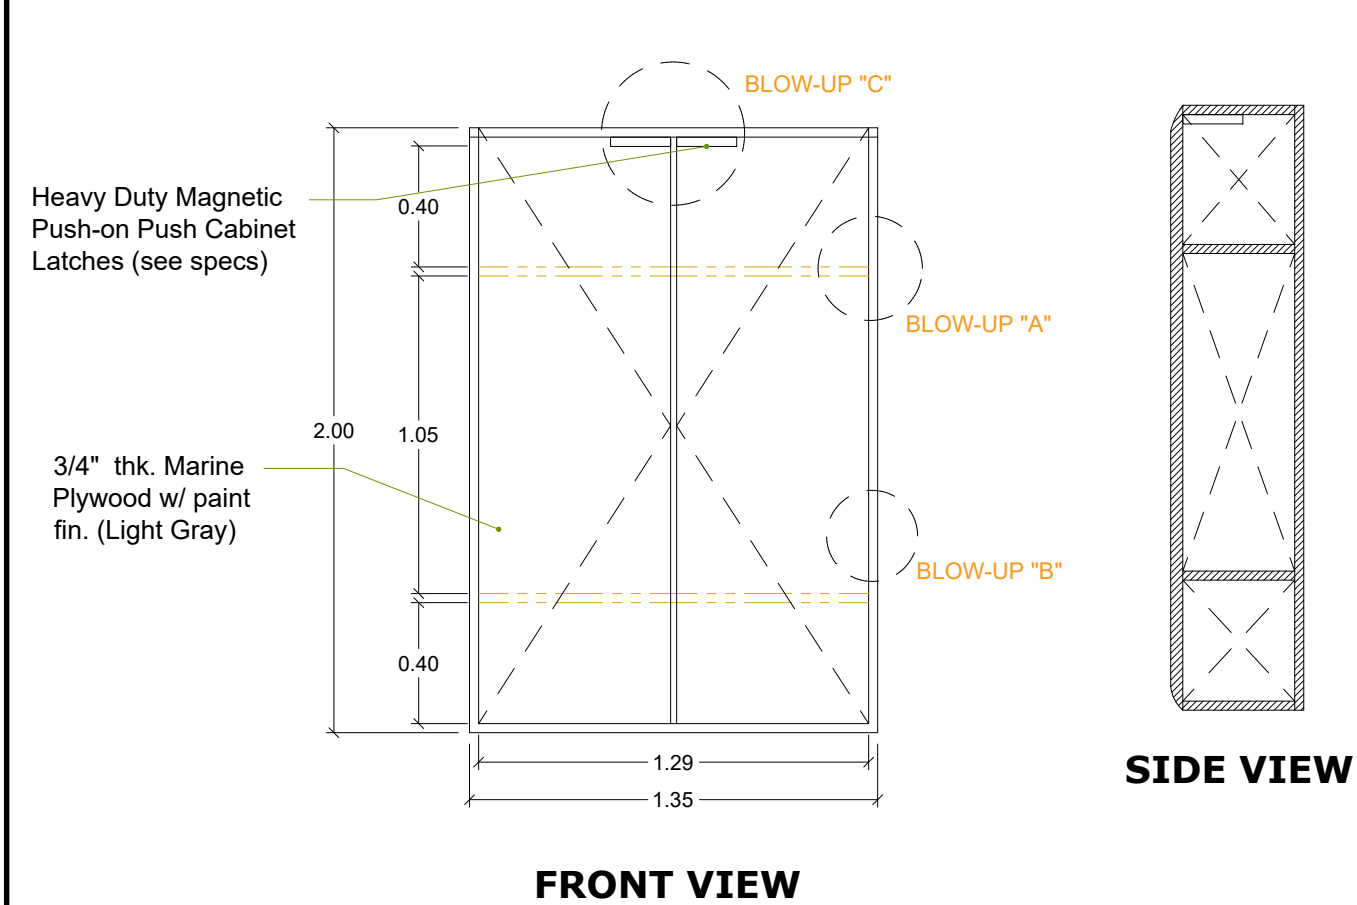


FRONT VIEW

SIDE VIEW

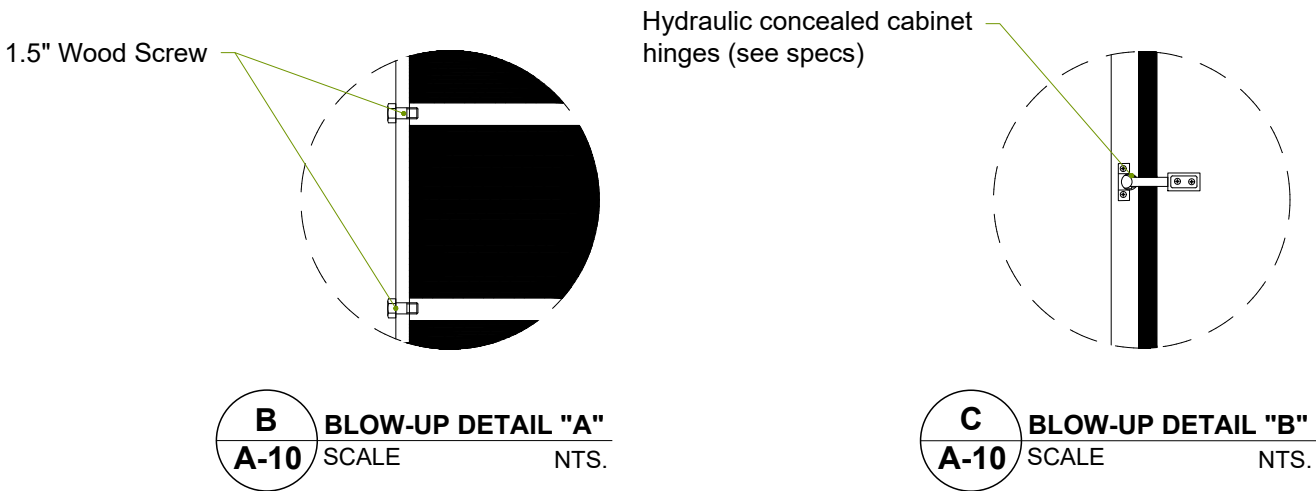


B BLOW-UP DETAIL "A" SCALE NTS.

C BLOW-UP DETAIL "B" SCALE NTS.

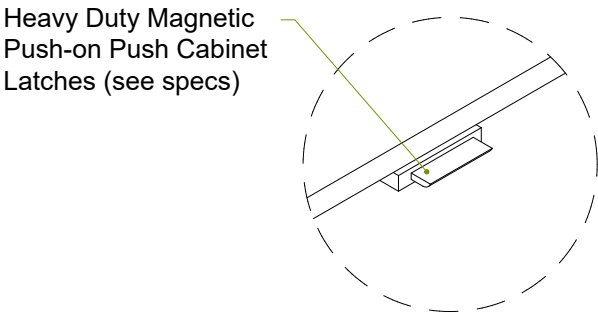


D BLOW-UP DETAIL "C" SCALE NTS.

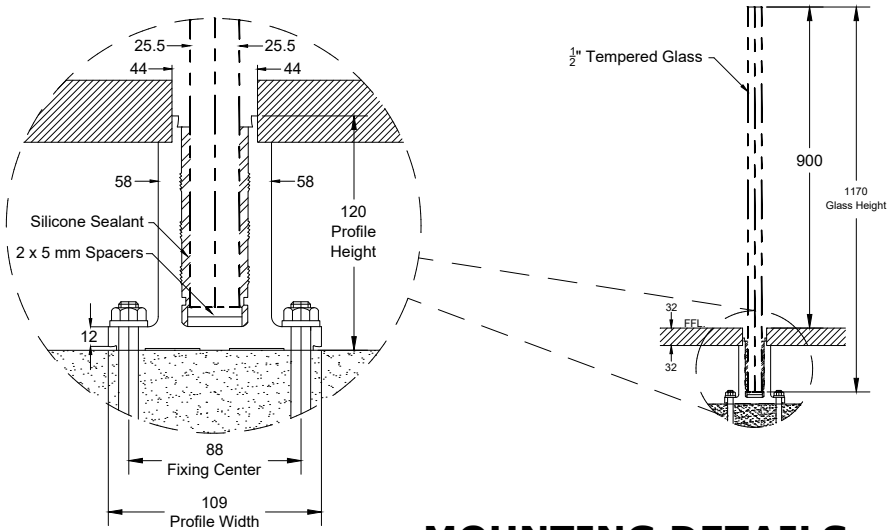


MOUNTING DETAILS


E GLASS RAILING DETAILS SCALE NTS.

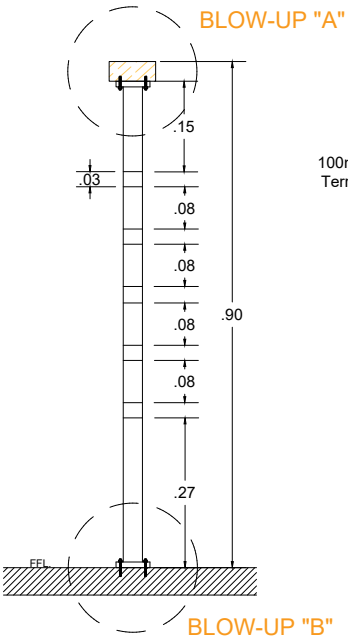

F STEEL RAILING DETAILS SCALE NTS.

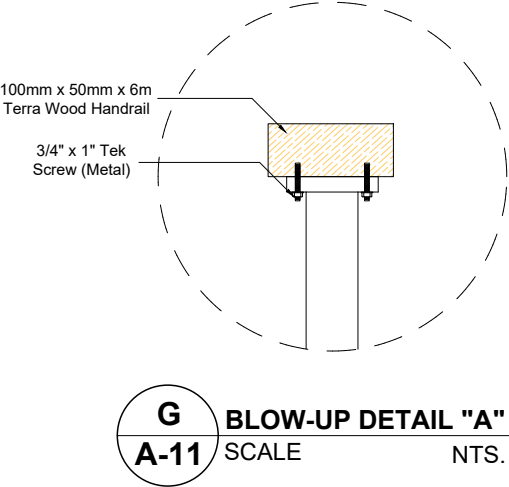


G BLOW-UP DETAIL "A" SCALE NTS.

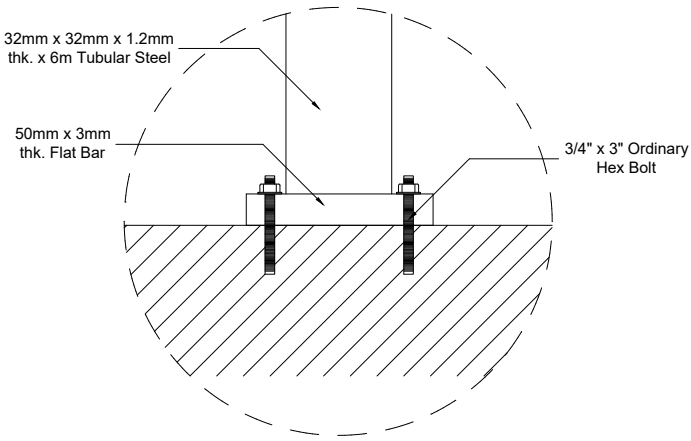


H BLOW-UP DETAIL "A" SCALE NTS.


SOUTHERN LEYTE STATE UNIVERSITY Main Campus, San Roque, Sogod, Southern Leyte Email: president@southernleytestateu.edu.ph Website: www.southernleytestateu.edu.ph	PREPARED BY :		PROJECT :	OWNER :	APPROVED AS PER PLAN :	SHEET CONTENT	SHEET NO.
	BYRON A. ENGASTON	AR. JEAMES PAUL EVANGELISTA, UAP	CONSTRUCTION OF 3-STOREY, 30 ROOMS APARTELLE DE SLSU PHASE I	SOUTHERN LEYTE STATE UNIVERSITY	JUDE A. DUARTE, DPA UNIVERSITY PRESIDENT	AS SHOWN	A-11
	MARJORIE G. ELEJORDE	ARCHITECT					
	MARK CIELO A. UYPALA	ENGR. RYAN A. MACUTO, GREEN ADP+AA					
Excellence Service Leadership and Good Governance Innovation Social Responsibility Integrity Professionalism Spirituality	DRAFTING AIDE-QJT	LUDIP Head Designate	ADDRESS: SLSU-MAIN CAMPUS, SAN ROQUE, SOGOD SOUTHERN LEYTE	ADDRESS: SLSU-MAIN CAMPUS, SAN ROQUE, SOGOD SOUTHERN LEYTE		CHECKED : APPROVED :	SCALE AS SHOWN @ 20x30 PROJ. NO.

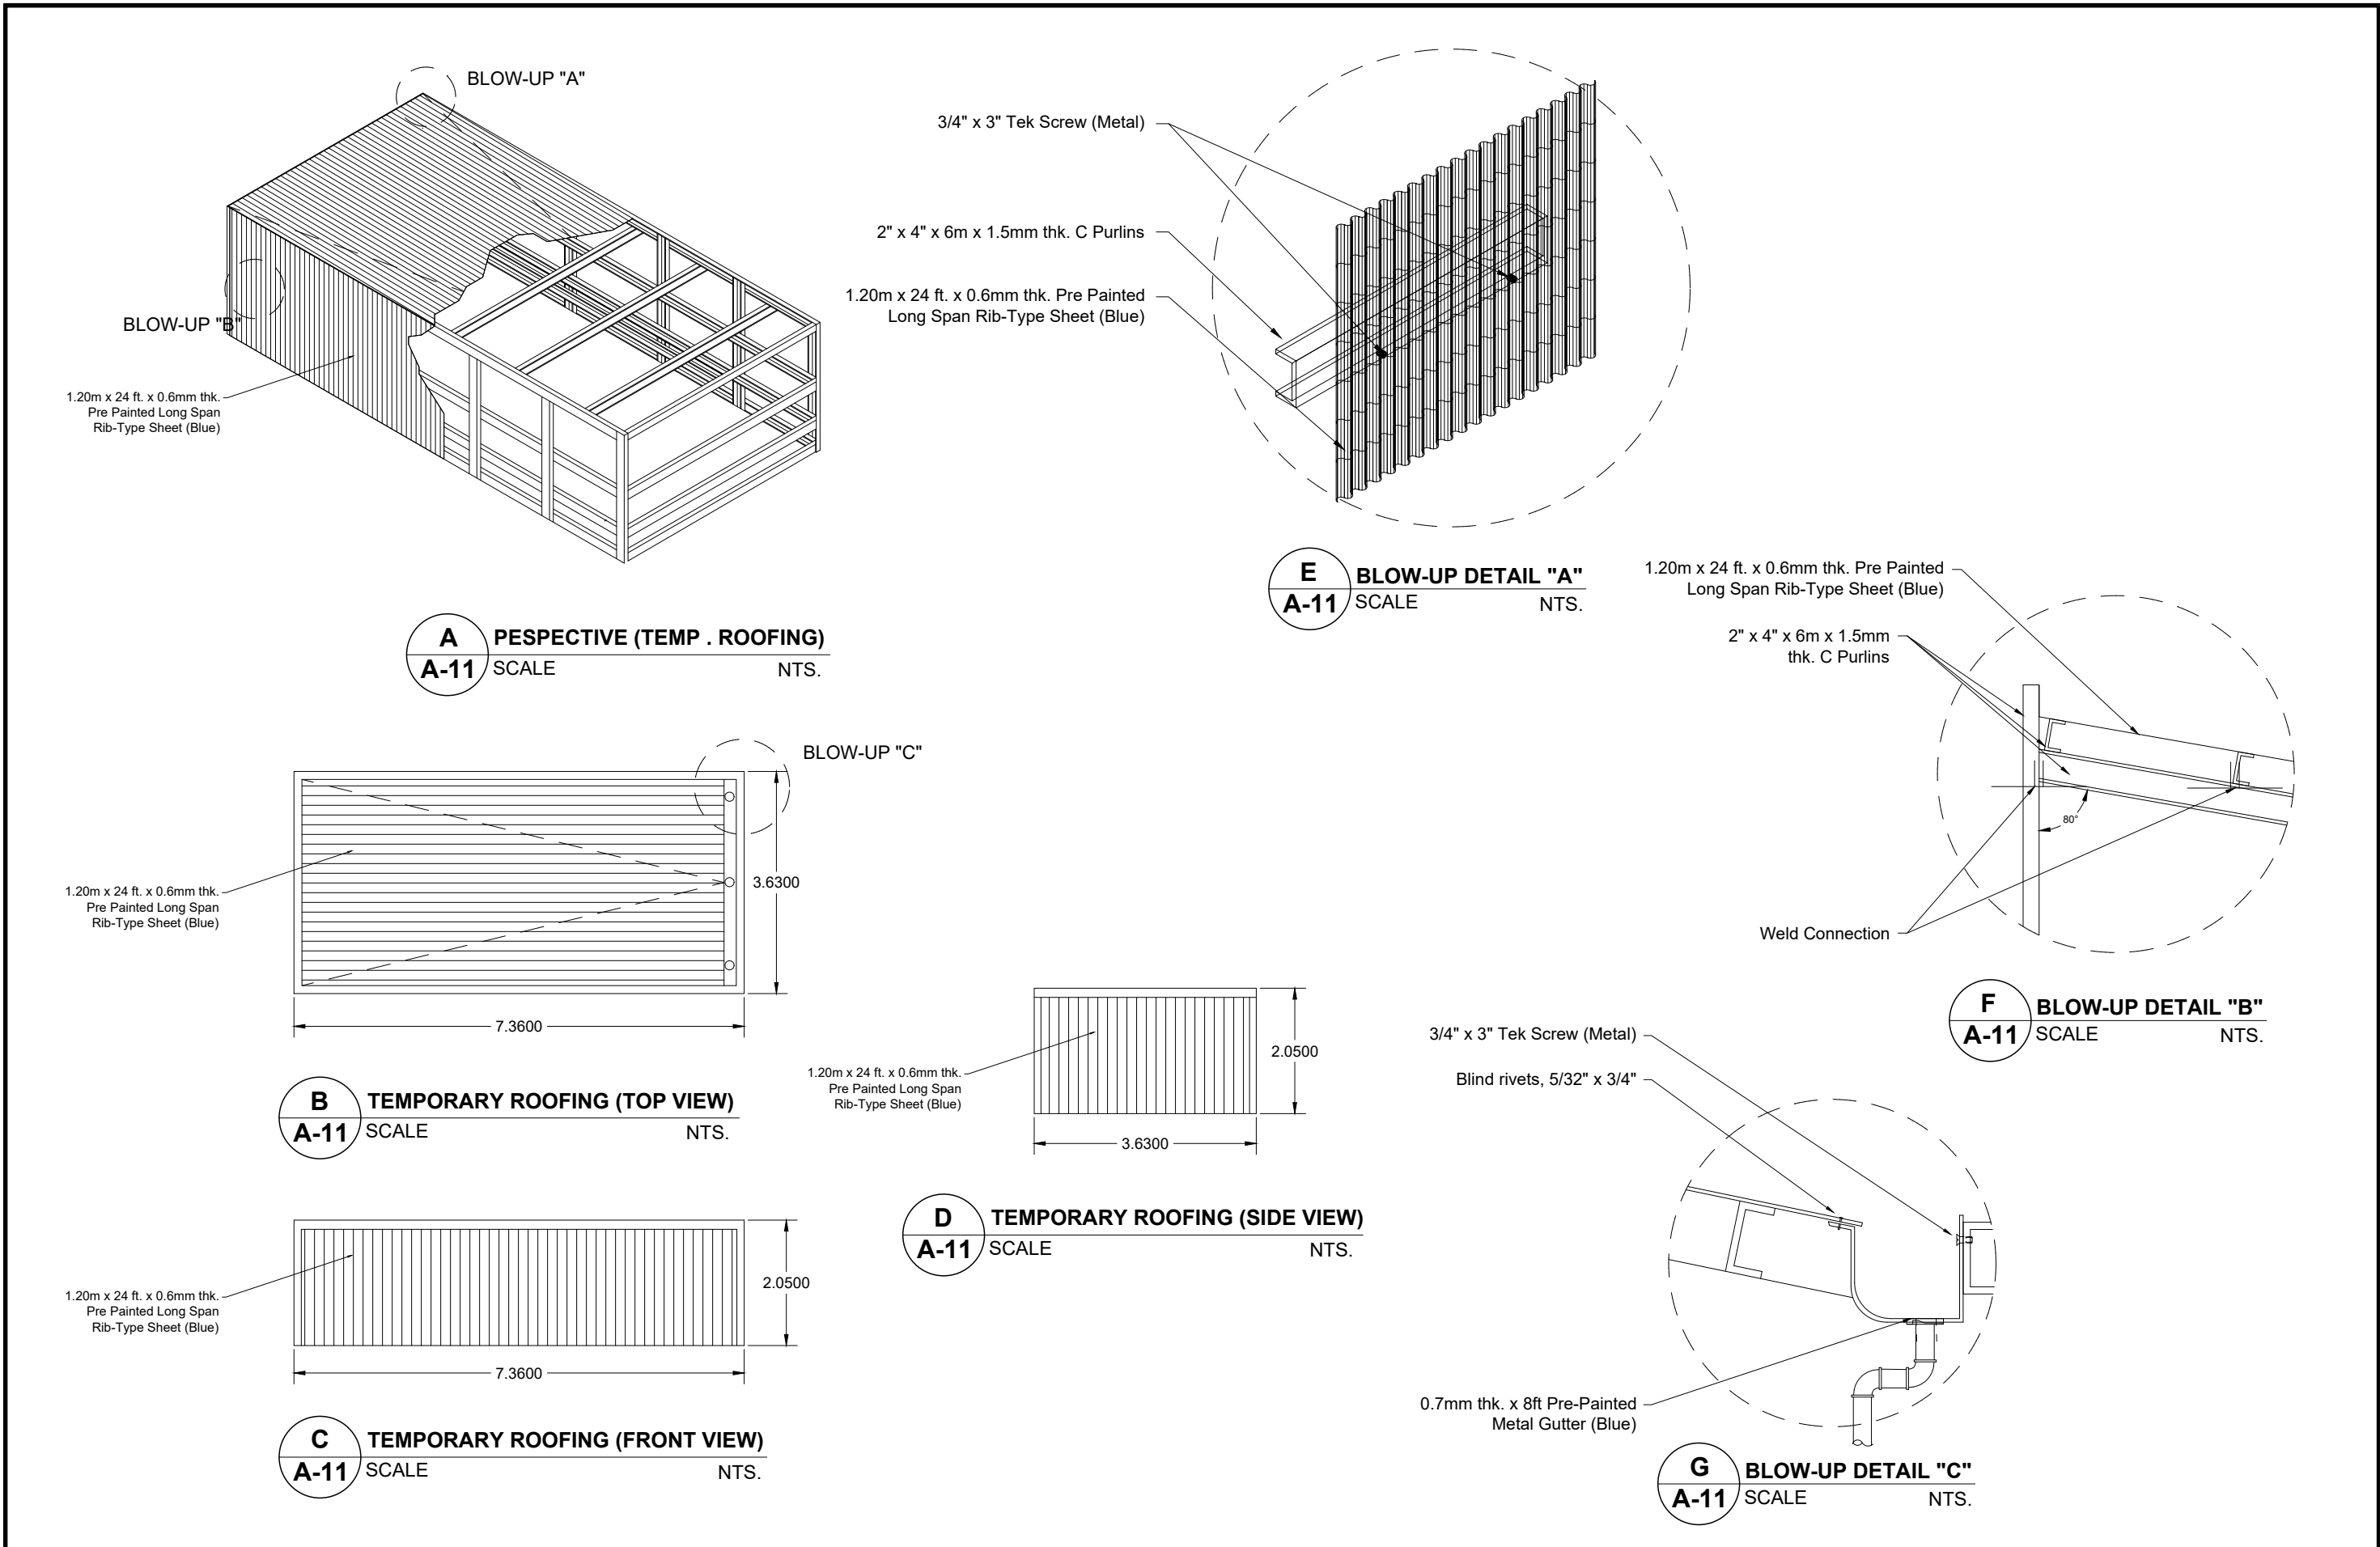


 SOUTHERN LEYTE STATE UNIVERSITY Main Campus, San Roque, Sogod, Southern Leyte Email: president@southernleytestateu.edu.ph Website: www.southernleytestateu.edu.ph	PREPARED BY :		PROJECT :	OWNER :	APPROVED AS PER PLAN :	SHEET CONTENT		SHEET NO.
	BYRON A. ENGASTON	AR. JEAMES PAUL EVANGELISTA, UAP	CONSTRUCTION OF 3-STOREY, 30 ROOMS APARTELLE DE SLSU PHASE I	SOUTHERN LEYTE STATE UNIVERSITY	JUDE A. DUARTE, DPA UNIVERSITY PRESIDENT	AS SHOWN		A-12
	MARJORIE G. ELEJORDE	ARCHITECT						
	MARK CIELO A. UYPALA	ENGR. RYAN A. MACUTO, GREEN ADP+AA						
Excellence Service Leadership and Good Governance Innovation Social Responsibility Integrity Professionalism Spirituality	DRAFTING AIDE-QJT	LUDIP Head Designate	ADDRESS: SLSU-MAIN CAMPUS, SAN ROQUE, SOGOD SOUTHERN LEYTE	ADDRESS: SLSU-MAIN CAMPUS, SAN ROQUE, SOGOD SOUTHERN LEYTE		CHECKED : APPROVED :	DRAWN : DATE :	SCALE AS SHOWN @ 20x30 PROJ. NO.

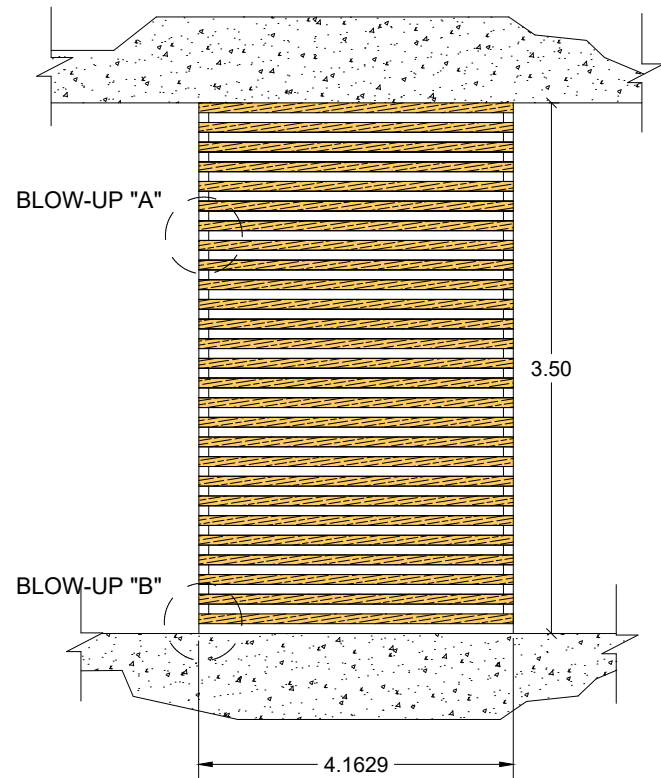


A
A-13 SCALE NTS.
SUNBREAKER DETAIL

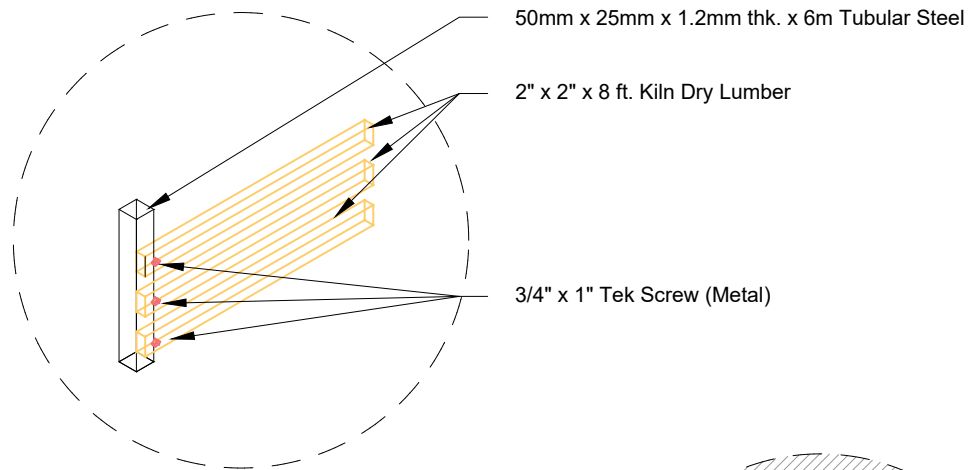


C
A-13 SCALE NTS.
SUNBREAKER BLOW-UP DETAIL "A"

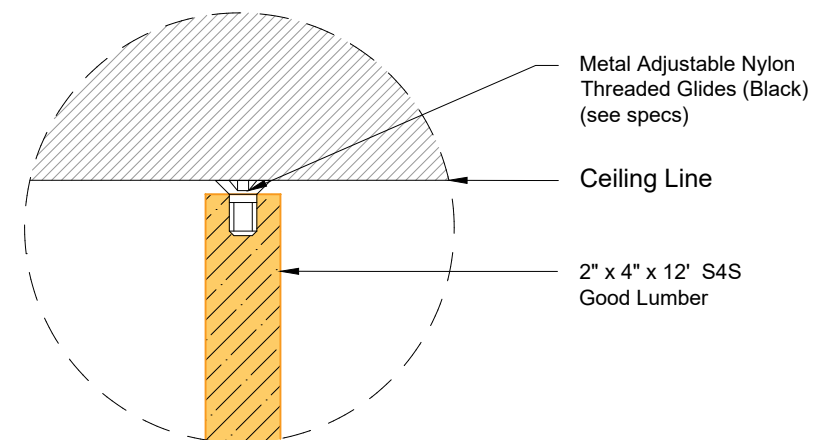


E
A-13 SCALE NTS.
WOODEN SLAT BLOW-UP DETAIL "A"

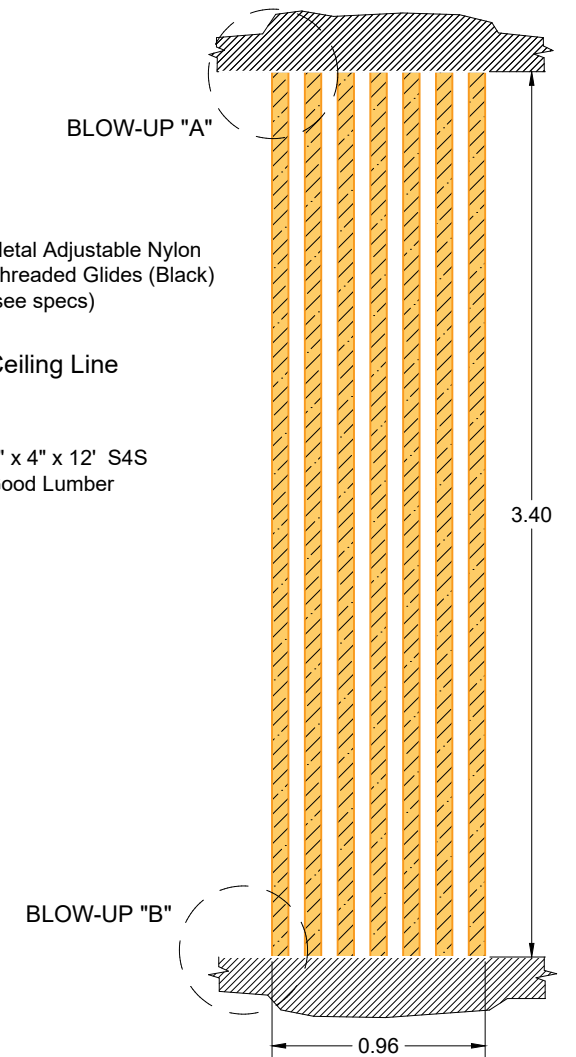

D
A-13 SCALE NTS.
WOODEN SLAT DETAIL














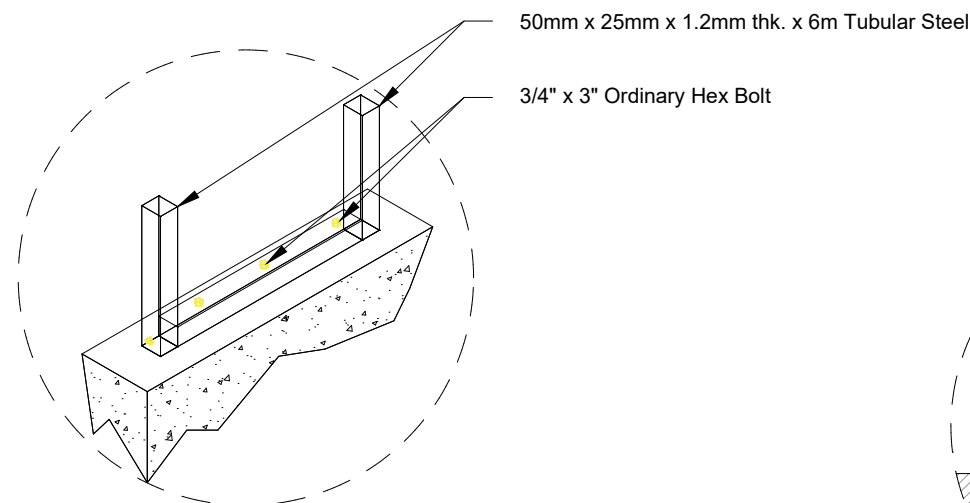













B
A-13 SCALE NTS.
SUNBREAKER BLOW-UP DETAIL "B"






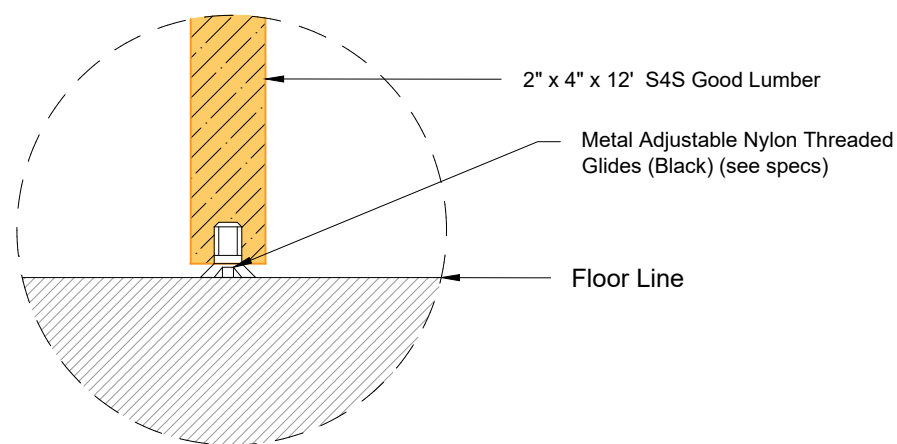


F
A-13 SCALE NTS.
WOODEN SLAT BLOW-UP DETAIL "B"

PREPARED BY :			PROJECT :	OWNER :	APPROVED AS PER PLAN :	SHEET CONTENT	SHEET NO.
BYRON A. ENGASTON	AR. JEAMES PAUL EVANGELISTA, UAP	CONSTRUCTION OF 3-STOREY, 30 ROOMS APARTELLE DE SLSU PHASE I	ADDRESS: SLSU-MAIN CAMPUS, SAN ROQUE, SOGOD SOUTHERN LEYTE	SOUTHERN LEYTE STATE UNIVERSITY	JUDE A. DUARTE, DPA UNIVERSITY PRESIDENT	AS SHOWN	A-13
MARJORIE G. ELEJORDE	ARCHITECT					CHECKED : DRAWN : APPROVED : DATE :	PROJ. NO.
MARK CIELO A. UYPALA	ENGR. RYAN A. MACUTO, GREEN ADP+AA					SCALE AS SHOWN @ 20x30	
DRAFTING AIDE-QJT	LUDIP Head Designate						

      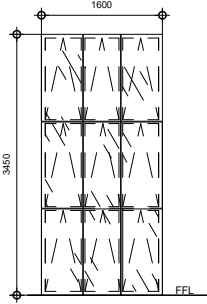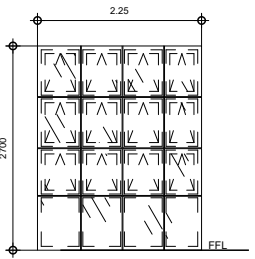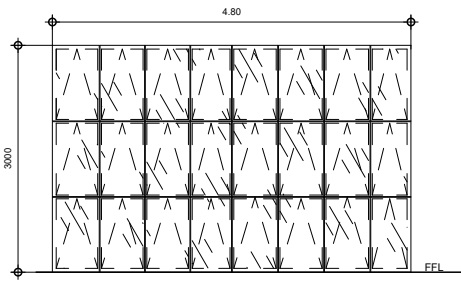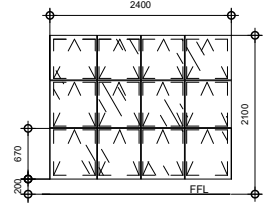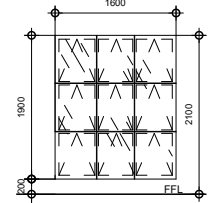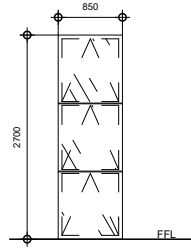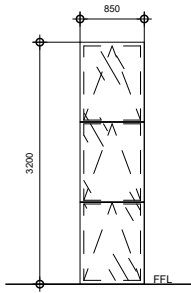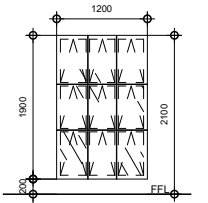SCHEDULE OF WINDOWS	PLAN								
	ELEVATION								
MARK									
LOCATION		AS SHOWN IN THE PLAN	AS SHOWN IN THE PLAN	AS SHOWN IN THE PLAN	AS SHOWN IN THE PLAN	AS SHOWN IN THE PLAN	AS SHOWN IN THE PLAN	AS SHOWN IN THE PLAN	AS SHOWN IN THE PLAN
QUANTITY		1 SETS	2 SETS	1 SET	8 SETS	2 SET	1 SET	1 SET	1 SET
SPECIFICATIONS		FIXED GLASS PANEL USING 1/2" TINTED GLASS (LIGHT GRAY) W/ 1½"X 4" POWDER COATED FRAME W/ 9-AWNING WINDOW PANELS	HIDDEN FRAMED FIXED GLASS PANEL USING 1/4" TINTED GLASS (LIGHT GRAY) W/ 1½"X 4" POWDER COATED FRAME W/ AWNING WINDOW PANELS	HIDDEN FRAMED FIXED GLASS PANEL USING 1/4" TINTED GLASS (LIGHT GRAY) W/ 1½"X 4" POWDER COATED FRAME W/ AWNING WINDOW PANELS	HIDDEN FRAMED FIXED GLASS PANEL USING 1/4" TINTED GLASS (LIGHT GRAY) W/ 1½"X 4" POWDER COATED FRAME W/ AWNING WINDOW PANELS	HIDDEN FRAMED FIXED GLASS PANEL USING 1/4" TINTED GLASS (LIGHT GRAY) W/ 1½"X 4" POWDER COATED FRAME W/ AWNING WINDOW PANELS	HIDDEN FRAMED FIXED GLASS PANEL USING 1/4" TINTED GLASS (LIGHT GRAY) W/ 1½"X 4" POWDER COATED FRAME W/ AWNING WINDOW PANELS	HIDDEN FRAMED FIXED GLASS PANEL USING 1/4" TINTED GLASS (LIGHT GRAY) W/ 1½"X 4" POWDER COATED FRAME W/ AWNING WINDOW PANELS	HIDDEN FRAMED FIXED GLASS PANEL USING 1/4" TINTED GLASS (LIGHT GRAY) W/ 1½"X 4" POWDER COATED FRAME W/ AWNING WINDOW PANELS

  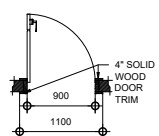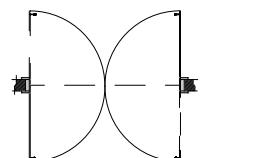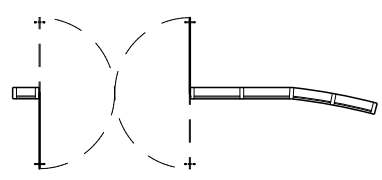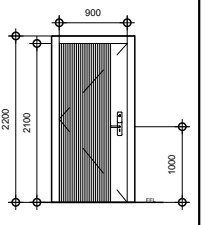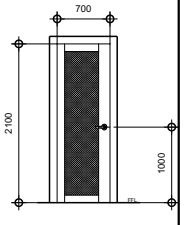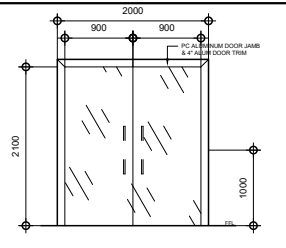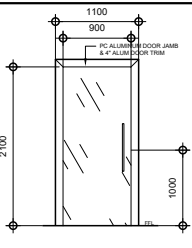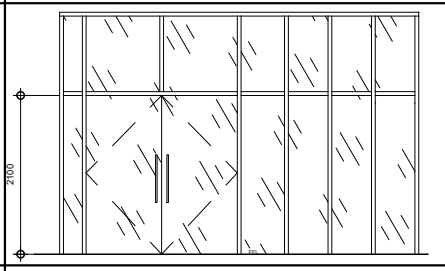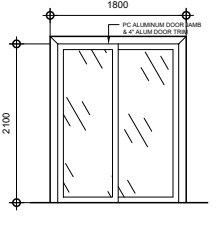SCHEDULE OF DOORS	PLAN						
	ELEVATION						
MARK							
LOCATION		AS SHOWN IN THE PLAN	AS SHOWN IN THE PLAN	AS SHOWN IN THE PLAN	AS SHOWN IN THE PLAN	AS SHOWN IN THE PLAN	AS SHOWN IN THE PLAN
QUANTITY		8 SETS	10 SETS	1 SET	2 SETS	1 SET	2 SETS
SPECIFICATIONS		VERTICAL SLATTED SOLID DOOR W/ DOOR JAMB AND TRIM (MAHOGANY FINISH)	SOLID DOOR WITH ¼\" data-bbox="210 815 275 850"/>	FRAMELESS HEAVY DUTY DOUBLE SWING 1/2\" data-bbox="280 815 365 845"/>	FRAMELESS HEAVY DUTY DOUBLE SWING 1/2\" data-bbox="370 815 435 850"/>	FRAMELESS HEAVY DUTY DOUBLE SWING TEMPERED GLASS DOOR (W/ CONCEALED HEAVY DUTY DOOR CLOSER) ON A 2\" data-bbox="445 815 575 850"/>	POWDER COATED ALUMINUM FRAMED SLIDING DOOR USING 1/4\" data-bbox="580 815 655 850"/>

   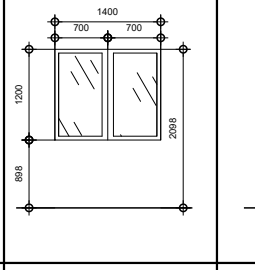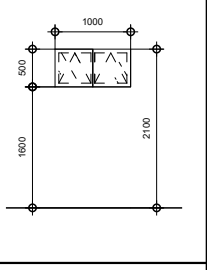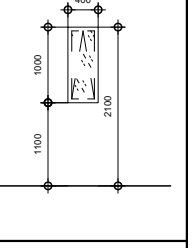SCHEDULE OF WINDOWS	PLAN			
	ELEVATION			
MARK				
LOCATION		AS SHOWN IN THE PLAN	AS SHOWN IN THE PLAN	AS SHOWN IN THE PLAN
QUANTITY		5 SETS	9 SETS	2 SET
SPECIFICATIONS		1½\" data-bbox="715 810 795 845"/>	1½\" data-bbox="790 810 855 845"/>	1½\" data-bbox="865 810 925 845"/>